


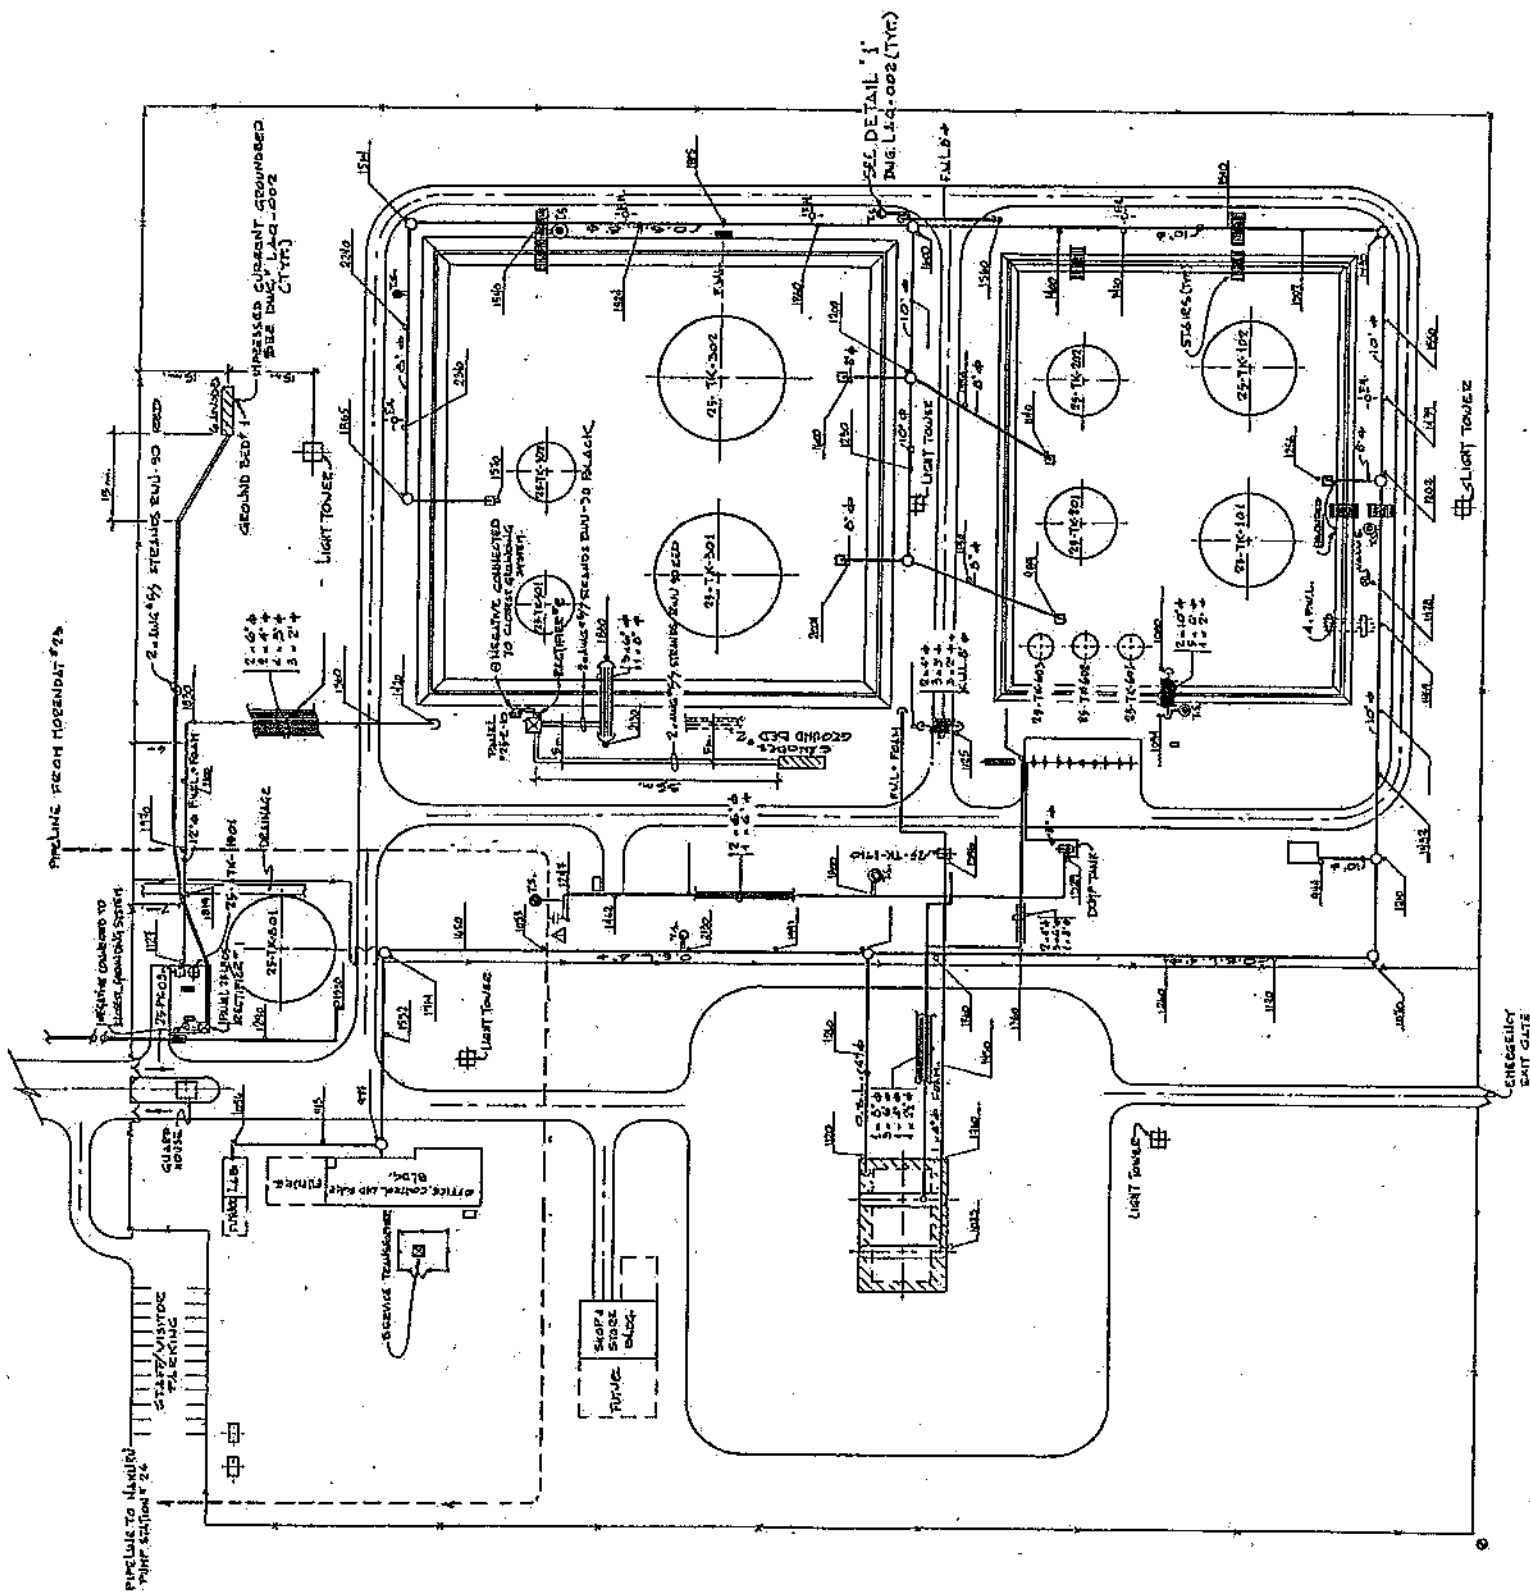

LEGEND:

- CATHODIC PROTECTION
ANODES SHALL BE 500 MM²
SILICON CARBIDE ANODES
WITH SILICON CARBIDE ANODE
ANODES GROUND BED
- ⌊ HEATING CONNECTION
(THERMIT WELD) TO
UNDERGROUND LINE
- ⊠ ELECTRICAL PANEL CONTAINING
ELECTRICAL

NOTE:

SUBCONTRACTOR SHALL CHECK AND VERIFY
THE LOCATIONS OF ALL UNDERGROUND PIPES
(STEEL, PVC, OTHER) AND CLOSING BEFORE ANY
DIGGING EXCAVATING

AS BUILT

Sheet No.	Rev.	Rev. Description	Rev. Date
01-01	01	Initial Issue	11/11/2011
01-02	02	As Built	11/11/2011
01-03	03	Final	11/11/2011

COREXCO INC.	
CORPORATION INTERESTS IN CONNECTION	
Project No.	11-001
Project Name	LAVALIN INTERVENTIONAL INC.
Project Location	WEST KENIA PIPELINE EXTENSION PROJECT
Project Type	CATHODIC PROTECTION
Project Size	1.5 KM
Project Status	LAUNCH SURVEY
Project Date	11/11/2011
Project Drawn	11/11/2011
Project Checked	11/11/2011
Project Approved	11/11/2011

A1-25-EE-001 REV.1

DRAWING INDEX

1	2	3	4	5	6
LOAD PUMP - MSP 25-P-02A/02B MOTOR SCHEMATIC AND WIRING DIAGRAM	A1-25-EE-7503	PLANT LIGHTING PANEL SCHEDULES	A1-25-EE-4301	DRAWING INDEX	A1-25-EE-2100
LOAD PUMP - AGO 25-P-03A MOTOR SCHEMATIC AND WIRING DIAGRAM	A1-25-EE-7504	OFFICE, CONTROL AND SWGR. BLDG. AREA POWER AND CONTROL LAYOUT	A1-25-EE-6101	ELECTRICAL PLAN SYMBOLS	A1-01-EE-2101
LOAD PUMP - AGO 25-P-03B MOTOR SCHEMATIC AND WIRING DIAGRAM	A1-25-EE-7505	EAST TANK FARM - SHT. 1 POWER AND CONTROL LAYOUT	A1-25-EE-6102	SINGLE LINE AND SCHEMATIC SYMBOLS	A1-01-EE-2102
LOAD PUMP - IK 25-P-04A/04B MOTOR SCHEMATIC AND WIRING DIAGRAM	A1-25-EE-7506	EAST TANK FARM - SHT. 2 POWER AND CONTROL LAYOUT	A1-25-EE-6103	KEY PLAN NORTH	A1-25-EE-2103
OWS OIL/WATER 25-P-07A/07B MOTOR SCHEMATIC AND WIRING DIAGRAM	A1-25-EE-7507	WEST TANK FARM - SHT. 1 POWER AND CONTROL LAYOUT	A1-25-EE-6104	KEY PLAN SOUTH	A1-25-EE-2104
INTERFACE LOAD PUMP 25-P-05 MOTOR SCHEMATIC AND WIRING DIAGRAM	A1-25-EE-7508	PROVER AND METERING AREA POWER AND CONTROL LAYOUT	A1-25-EE-6105	ELECTRICAL MATERIAL LIST	A1-01-EE-2105
BLENDING PUMP A/B 25-P-11A/11B MOTOR SCHEMATIC AND WIRING DIAGRAM	A1-25-EE-7509	LOADING PUMP AND MANIFOLD POWER AND CONTROL LAYOUT	A1-25-EE-6106	ELECTRICAL MATERIAL LIST	A1-01-EE-2106
DUMP PUMP 25-P-06 MOTOR SCHEMATIC AND WIRING DIAGRAM	A1-25-EE-7510	SEPARATOR AREA POWER AND CONTROL LAYOUT	A1-25-EE-6107	FENCE EARTHING AND AREA TRENCHING PLAN - NORTH	A1-25-EE-2107
EXHAUST FAN 25-K-01/YARD LTG. 25-LF-01 SCHEMATIC AND WIRING DIAGRAM	A1-25-EE-7511	TRUCK LOADING SHELTER AREA POWER AND CONTROL LAYOUT	A1-25-EE-6108	FENCE EARTHING AND AREA TRENCHING PLAN - SOUTH	A1-25-EE-2108
415 - 3PH. MOV WIRING DIAGRAM AND CONTROL WIRING SCHEMATIC	A1-25-EE-7515	OFFICE, CONTROL & SWITCHGEAR BUILDING POWER AND CONTROL LAYOUT	A1-25-EE-6109	LOW VOLTAGE SINGLE LINE DIAGRAM	A1-25-EE-2201
AREA LIGHTING SCHEMATIC	A1-25-EE-7519	WEST TANK FARM - SHT. 2 POWER AND CONTROL LAYOUT	A1-25-EE-6111	LOW VOLTAGE SINGLE LINE DIAGRAM	A1-25-EE-2202
TERMINAL BOX CTB-1 WIRING DIAGRAM	A1-25-EE-7601	FIRE PUMP SHELTER POWER AND CONTROL LAYOUT	A1-25-EE-6112	LOW VOLTAGE SINGLE LINE DIAGRAM	A1-25-EE-2203
TERMINAL BOX CTB-2 WIRING DIAGRAM	A1-25-EE-7602	POWER AND CONTROL DETAILS	A1-01-EE-6201	LOW VOLTAGE SINGLE LINE DIAGRAM	A1-25-EE-2204
TERMINAL BOX CTB-3 WIRING DIAGRAM	A1-25-EE-7603	TRUCK LOADING SHELTER, ISLAND #1 POWER AND CONTROL DETAILS	A1-25-EE-6202	UPS SYSTEM SINGLE LINE DIAGRAM	A1-25-EE-2206
TERMINAL BOX DTB-1 WIRING DIAGRAM	A1-25-EE-7606	TRUCK LOADING SHELTER, ISLAND #2 POWER AND CONTROL DETAILS	A1-25-EE-6203	PLANT EARTHING SYSTEM SCHEMATIC	A1-25-EE-2207
TERMINAL BOX DTB-2 WIRING DIAGRAM	A1-25-EE-7607	CABLE TRAY DETAILS	A1-01-EE-6205	AREA CLASSIFICATION PLAN NORTH	A1-25-EE-3101
TERMINAL BOX DTB-3 WIRING DIAGRAM	A1-25-EE-7608	POWER AND CONTROL CABLE SCHEDULE	A1-01-EE-6206	AREA CLASSIFICATION PLAN SOUTH	A1-25-EE-3102
TERMINAL BOX DTB-4 WIRING DIAGRAM	A1-25-EE-7609	POWER AND CONTROL CABLE SCHEDULE	A1-25-EE-6301	AREA CLASSIFICATION DETAILS	A1-25-EE-3201
TERMINAL BOX DTB-5 WIRING DIAGRAM	A1-25-EE-7610	INSTRUMENTATION DETAILS	A1-01-EE-7201	OFFICE, CONTROL AND SWGR. BLDG. AREA LIGHTING AND EARTHING LAYOUT	A1-25-EE-4101
TERMINAL BOX ATB-1 WIRING DIAGRAM	A1-25-EE-7612	INSTRUMENTATION DETAILS	A1-01-EE-7202	EAST TANK FARM - SHT. 1 LIGHTING AND EARTHING LAYOUT	A1-25-EE-4102
TERMINAL BOX KTB-1 AND KTB-2 WIRING DIAGRAM	A1-25-EE-7615	INSTRUMENTATION CABLE SCHEDULE (DISCRETE)	A1-25-EE-7301	EAST TANK FARM - SHT. 2 LIGHTING AND EARTHING LAYOUT	A1-25-EE-4103
TERMINAL BOX JB2-1A/1B, JB4-1A, JB5-1A/1B JB6-1A & JB7-1A WIRING DIAGRAM	A1-25-EE-7617	INSTRUMENTATION CABLE SCHEDULE (DISCRETE)	A1-25-EE-7302	WEST TANK FARM LIGHTING AND EARTHING LAYOUT	A1-25-EE-4104
TERMINAL BOX JB2-2A/1B, JB4-2A, JB5-2A/1B JB6-2A & JB7-2A WIRING DIAGRAM	A1-25-EE-7618	INSTRUMENTATION CABLE SCHEDULE (ANALOG)	A1-25-EE-7303	PROVER AND METERING AREA LIGHTING AND EARTHING LAYOUT	A1-25-EE-4105
NAMEPLATE SCHEDULE	A1-25-EE-9301	INSTRUMENTATION CABLE SCHEDULE (COMMUNICATION)	A1-25-EE-7304	LOADING PUMP AND MANIFOLD LIGHTING AND EARTHING LAYOUT	A1-25-EE-4106
		LOAD PUMP - MSR 25-P-01A MOTOR SCHEMATIC AND WIRING DIAGRAM	A1-25-EE-7501	SEPARATOR AREA LIGHTING AND EARTHING LAYOUT	A1-25-EE-4107
		LOAD PUMP - MSR 25-P-01B MOTOR SCHEMATIC AND WIRING DIAGRAM	A1-25-EE-7502	TRUCK LOADING SHELTER AREA LIGHTING AND EARTHING LAYOUT	A1-25-EE-4108

Kenya Pipeline Company Limited 49957 ACCOUNT No 4800 SCALE N.T.S. REV 0		Propipe Lawlin International Inc DRAWING No.		WEST KENYA PIPELINE EXTENSION PROJECT NAKURU TERMINAL No. 25 DRAWING INDEX	
JOB No. 49957 ACCOUNT No 4800 SCALE N.T.S. REV 0		ENGINEER STAMP PERMIT STAMP		REVISIONS No. BY CHK LEAD SEC PRL DATE 1/11/11 ISSUED FOR APPROVAL 2/11/11 ISSUED FOR APPROVAL	
DRAWING No.		DESCRIPTION		APPROVALS DATE	

PLAN SYMBOLS

EARTHING:

- MAIN EARTH LOOP 70mm²
(ABOVE GROUND IN TRAY AS PER PLAN)
- MAIN EARTH LOOP 70mm²
- EARTH BOND WIRE 35mm²
- EARTH BOND WIRE 16mm²
- EARTHING ELECTRODE
- EARTHING RISER
- BELOW GRADE BRANCH TAP
- ABOVE GRADE BRANCH TAP
- EARTHING CABLE AND CLAMP

INSTRUMENTATION:

- ANALOG DEVICE
- DISCRETE DEVICE
- SOLENOID
- TRANSMITTER
- TRANSDUCER
- TEMPERATURE ELEMENT

FIELD INSTRUMENT TAG NUMBER AS INDICATED ON P&ID DRAWING.
EL. X INDICATES APPROX. ELEVATION
IN METERS OR MILLIMETERS.

LIGHTING:

- FIXTURE DESIGNATION
TOP INDICATES FIXTURE TYPE
BOTTOM INDICATES FIXTURE SCHEDULE DRAWING
- LIGHTING FIXTURE PENDANT OR CEILING MOUNT
- LIGHTING FIXTURE WALL MOUNTED
- SURFACE OR PENDANT MOUNTED FLUORESCENT LIGHT FIXTURE
- RECESSED FLUORESCENT FIXTURE
- ROTATING BEACON (R=RED LIGHT)
- STROBE BEACON
- FLOODLIGHT TOWER

EMERGENCY POWER PACK

EXIT LIGHT

SINGLE RECEPTACLE 1 Ø. 13A, 240 VOLT
SUITABLE FOR ZONE 1

DUPLEX RECEPTACLE 1 Ø. 13A, 240 VOLT
UNCLASSIFIED (INDOOR USE)

POWER RECEPTACLE, WEATHERPROOF
415V, 3 Ø, 30A, METAL CLAD

S₁ SINGLE POLE SWITCH

S₂ 2-WAY SWITCH

LP-LIGHTING PANEL

TELEPHONE CABINET

GENERAL:

DETAIL OR MATERIAL DESIGNATION
TOP INDICATES DETAIL NUMBER
BOTTOM INDICATES THE DRAWING NUMBER
TYPE X INDICATES THE NUMBER OF PLACES

DISCONNECT

JUNCTION BOX

HERN

FIRE ALARM STATION

TRANSFORMER

MOTOR

PHOTOCELL

VIBRATION SWITCH

JUNCTION BOX

CONTROL STATION AS SPECIFIED

TELEPHONE OUTLET

MANUAL MOTOR STARTING SWITCH
WITH THERMAL OVERLOAD PROTECTION

THERMOSTAT

CONDUIT/CABLE EXPOSED

CONDUIT CAPPED

CONDUIT UNION

CONDUIT SEAL

CONDUIT FITTING AS REQUIRED

BURIED CABLE

EMERGENCY SHUT-DOWN BUTTON

- FIELD TERMINAL BOX (FTB)
- ATB-X ANALOG TERMINAL BOX
- CTB-X CONTROL TERMINAL BOX (ADV)
- DTB-X DISCRETE TERMINAL BOX
- MTB-X COMMUNICATION (LOOP) TERMINAL BOX

ANALOG CABLE

CONTROL CABLE

DISCRETE CABLE

FIRE ALARM CABLE

COMMUNICATION CABLE

RTD CABLE

POWER CABLE

BRANCH CIRCUIT FEEDER FROM LIGHTING PANEL


BRANCH CIRCUIT FEEDER FROM DISTRIBUTION PANEL

BRANCH CIRCUIT FEEDER FROM UPS PANEL

EMERGENCY SHUT-DOWN CONTROL CABLE

Propipe Kenya Pipeline Company Limited		JOB No 49957
Kenya Pipeline Company Limited		ACCOUNT No 4800
West Kenya Pipeline Extension Project		SCALE NTS
NAKURU TERMINAL No. 25		REV D
PLAN SYMBOLS		DRAWING No
REVISIONS		
NO	BY	CHK
1		
2		
3		
363		


SINGLE LINE AND SCHEMATIC SYMBOLS

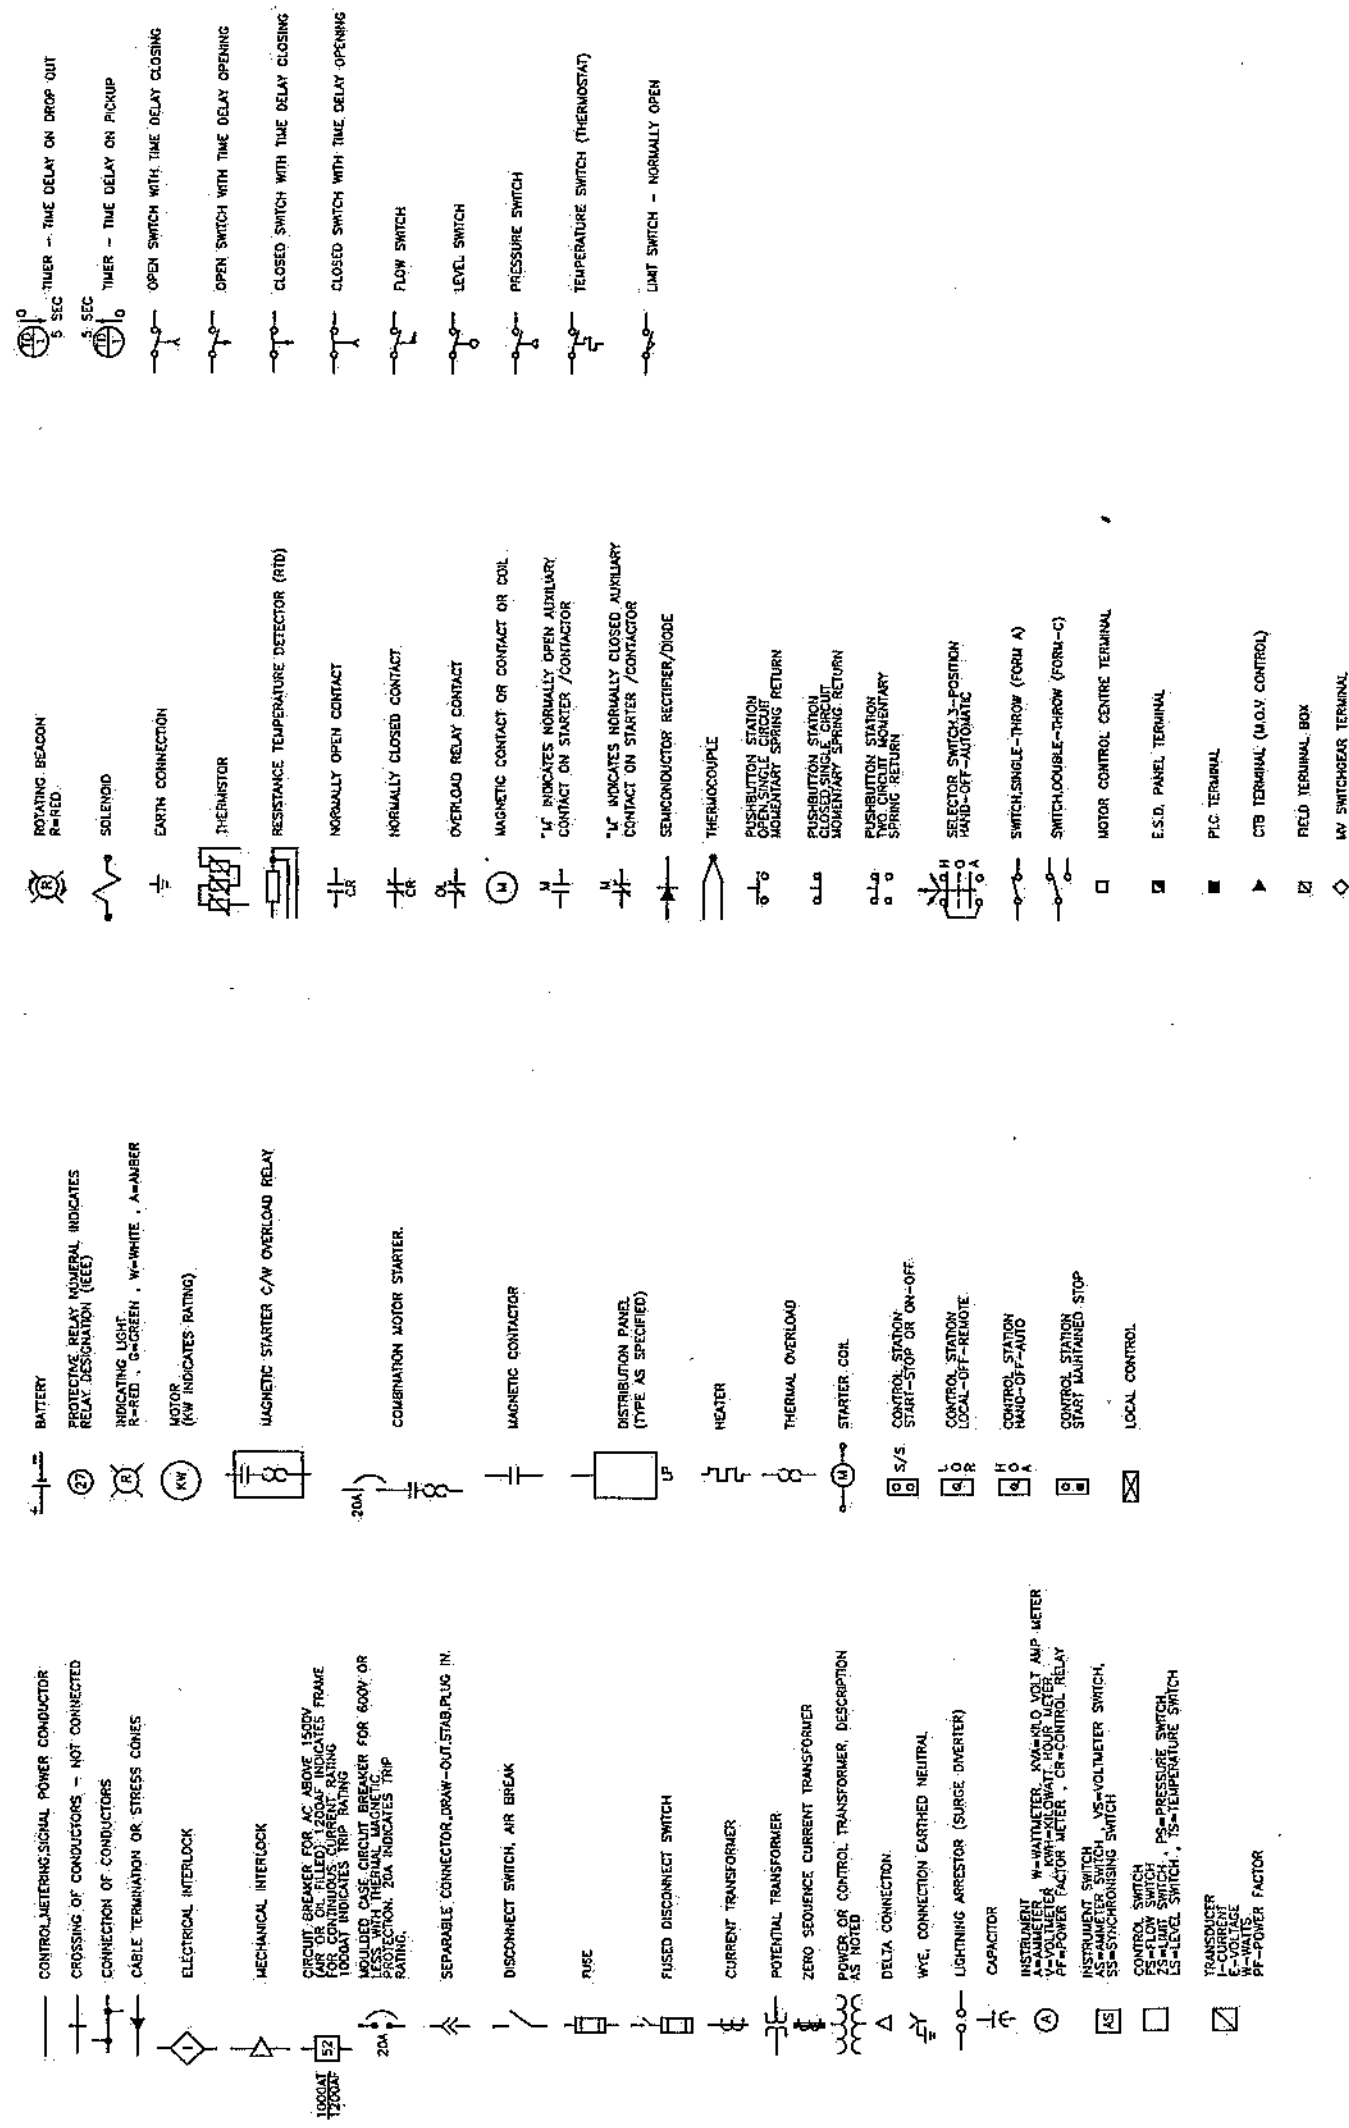[illegible]




PLANT NORTH



MATCHLINE S. 163.000 FOR CONTINUATION SEE DWG. No. A1-25-EE-2103

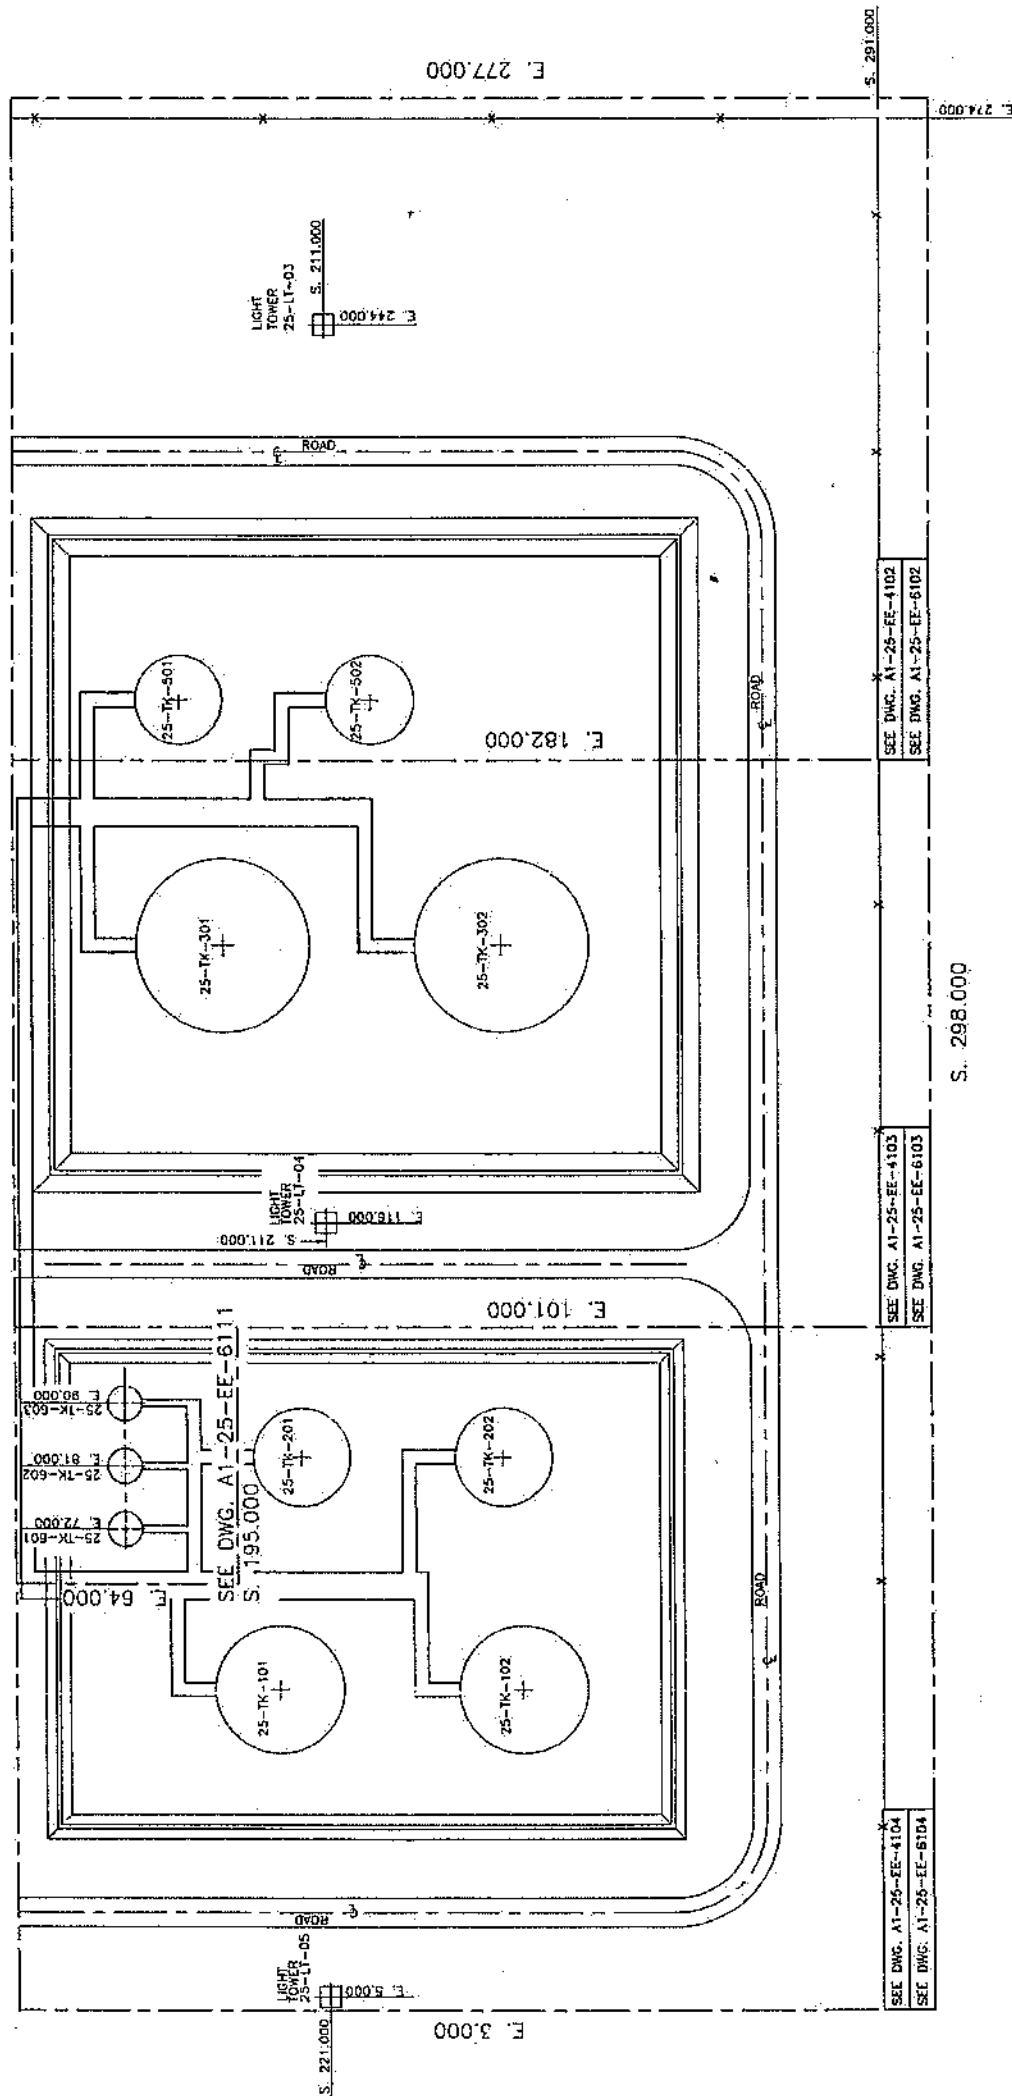

RECEIVED
19 MAR 1993
LAVANIN CORPORATION

JOB No. 49957		ACCOUNT No. 4600		SCALE 1:500		REV 1	
KENYA PIPELINE COMPANY LIMITED		WEST KENYA PIPELINE EXTENSION PROJECT NAKURU TERMINAL No. 25 KEY PLAN SOUTH					
Propipe		Lavanin International Inc					
DRAWING No.		PERMIT STAMP					
ENGINEER STAMP		APPROVALS					
DESIGN		CHECKED		DATE		DATE	
DRAWN		CHECKED		DATE		DATE	
DESIGNED		CHECKED		DATE		DATE	
LEAD		CHECKED		DATE		DATE	
PROJECT		CHECKED		DATE		DATE	
CONSTRUCTION		CHECKED		DATE		DATE	
ISSUED FOR CONSTRUCTION		CHECKED		DATE		DATE	
ISSUED FOR APPROVAL		CHECKED		DATE		DATE	
REVISIONS		REVISIONS		REVISIONS		REVISIONS	
No.		By		Date		Date	
1		25		09/04/93		09/04/93	
2		25		09/04/93		09/04/93	
3		25		09/04/93		09/04/93	
197		25		09/04/93		09/04/93	
198		25					

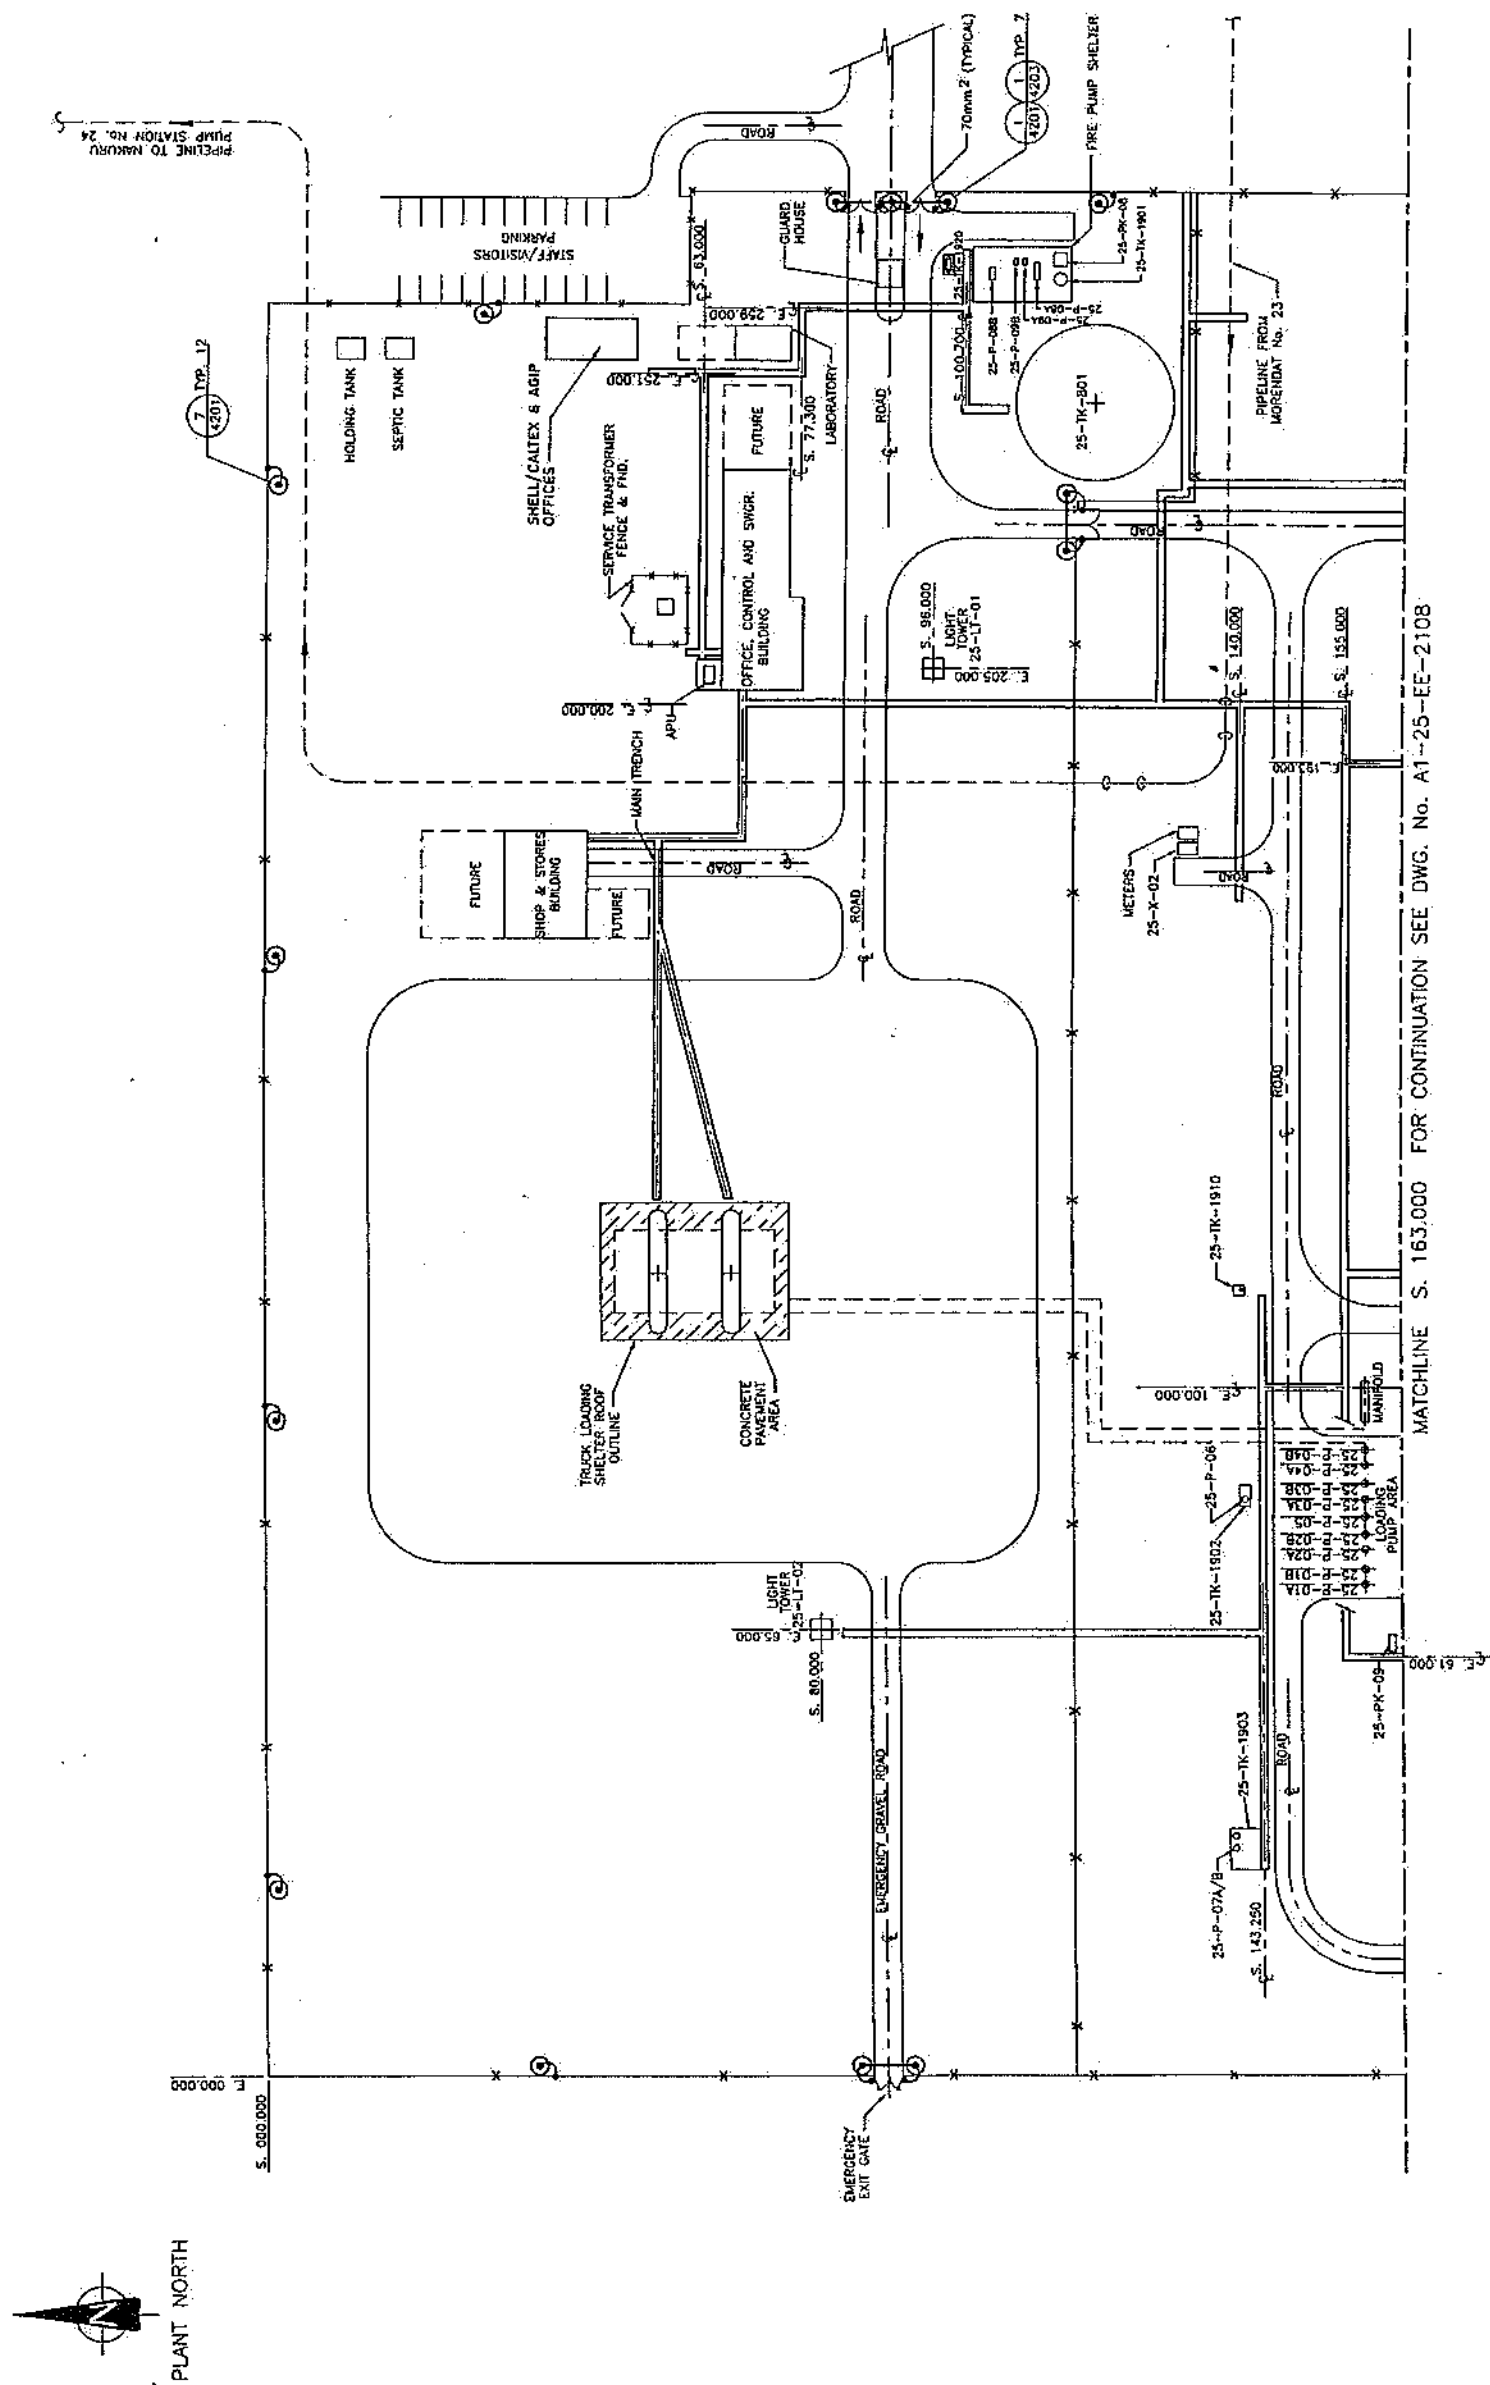
[illegible]

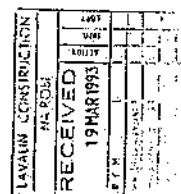 Plotted Date 1993-02-01 15:03:

LEGEND

- GENERATOR
- POWER FACTOR METER
- DIGITAL METERING SYSTEM
- KVA DEMAND METER
- VOLTMETER
- AMPMETER
- FREQUENCY METER
- AMMETER SWITCH
- VOLTMETER SWITCH
- VOLTAGE REGULATOR
- RED - INDICATES CLOSED/RUNNING
- GREEN - INDICATES OPEN/STOPPED
- AMBER - INDICATES MOTOR TRIPPED
- WHITE - INDICATES SUPPLY ON
- INTERLOCK
- PLC INPUT/OUTPUT
- HAND OFF AUTO SELECTOR SWITCH
- LOCAL OFF REMOVE SELECTOR SWITCH
- START/STOP PUSHBUTTONS
- START/STOP PUSHBUTTONS
- INDICATES MAINTAINED OFF
- THERMAL RELAY
- HEATER
- POSITIVE TEMPERATURE CO-EFFICIENT ELEMENT
- LOCAL STARTER/CONTROLLER
- PHOTO CELL
- MOTOR OPERATOR
- PRESSURE SWITCH
- LEVEL SWITCH
- THERMOSTAT
- KEY INTERLOCK
- MOTOR CIRCUIT PROTECTOR (MAGNETIC TRIP ONLY)
- SOLID STATE TRIP UNIT
- 3 POLE BREAKER WITH NEUTRAL DISCONNECT

415V MCC 25-E-04

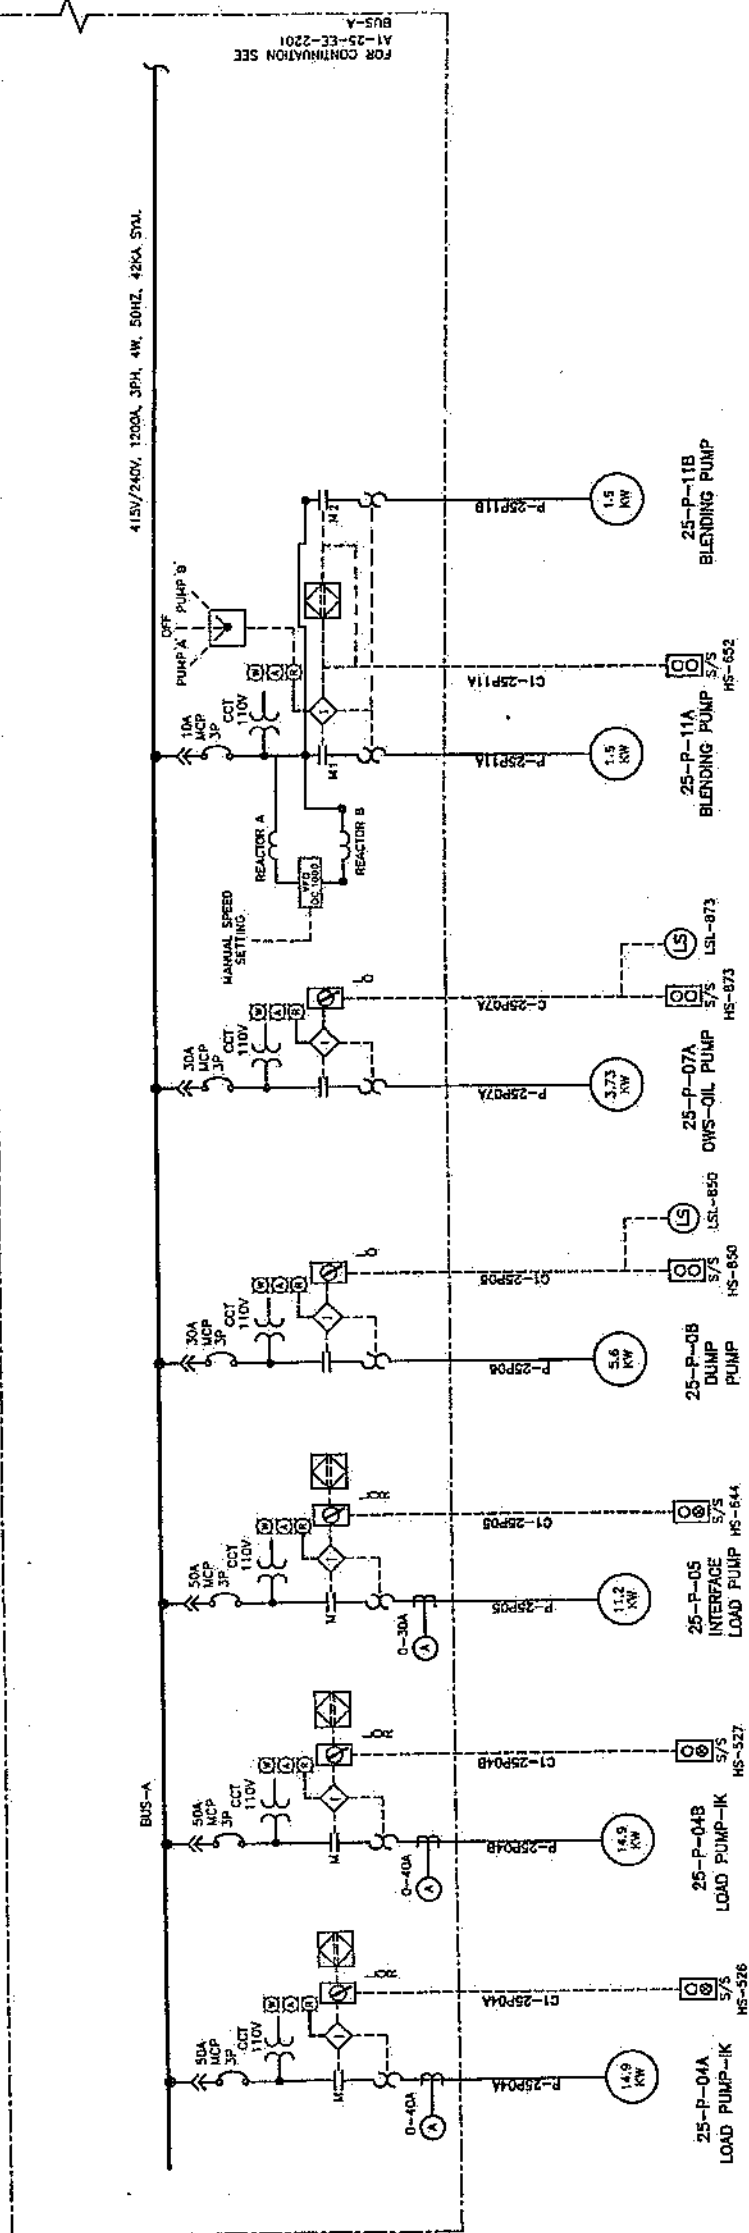



KENYA PIPELINE COMPANY LIMITED		Propipe		ENGINEER STAMP		PERMIT STAMP	
JOB No	49957	ACCOUNT No	1600	DESIGN	REVISION	DATE	DATE
SCALE	N.T.S	PROJECT	WEST KENYA PIPELINE EXTENSION PROJECT	DESIGNED	REVISION	DATE	DATE
REV	6	DRAWING No	NAKURU TERMINAL No 25	DRAWN	REVISION	DATE	DATE
LOW VOLTAGE SINGLE LINE DIAGRAM				CHECKED	REVISION	DATE	DATE
DWG No AT-25-EE-2202				APPROVED	REVISION	DATE	DATE
Filename : 25EE2202				DATE	DATE	DATE	DATE



REV	DATE	DESCRIPTION
1	01.02.20	ISSUE FOR DESIGN APPROVAL
2	01.02.20	ISSUE FOR CLIENT APPROVAL/QUOTE
3	01.02.20	ISSUE FOR CONSTRUCTION
4	01.02.20	ISSUE FOR CONSTRUCTION
5	01.02.20	ISSUE FOR CONSTRUCTION
6	01.02.20	ISSUE FOR CONSTRUCTION

REV	DATE	DESCRIPTION
1	01.02.20	ISSUE FOR DESIGN APPROVAL
2	01.02.20	ISSUE FOR CLIENT APPROVAL/QUOTE
3	01.02.20	ISSUE FOR CONSTRUCTION
4	01.02.20	ISSUE FOR CONSTRUCTION
5	01.02.20	ISSUE FOR CONSTRUCTION
6	01.02.20	ISSUE FOR CONSTRUCTION

REV	DATE	DESCRIPTION
1	01.02.20	ISSUE FOR DESIGN APPROVAL
2	01.02.20	ISSUE FOR CLIENT APPROVAL/QUOTE
3	01.02.20	ISSUE FOR CONSTRUCTION
4	01.02.20	ISSUE FOR CONSTRUCTION
5	01.02.20	ISSUE FOR CONSTRUCTION
6	01.02.20	ISSUE FOR CONSTRUCTION

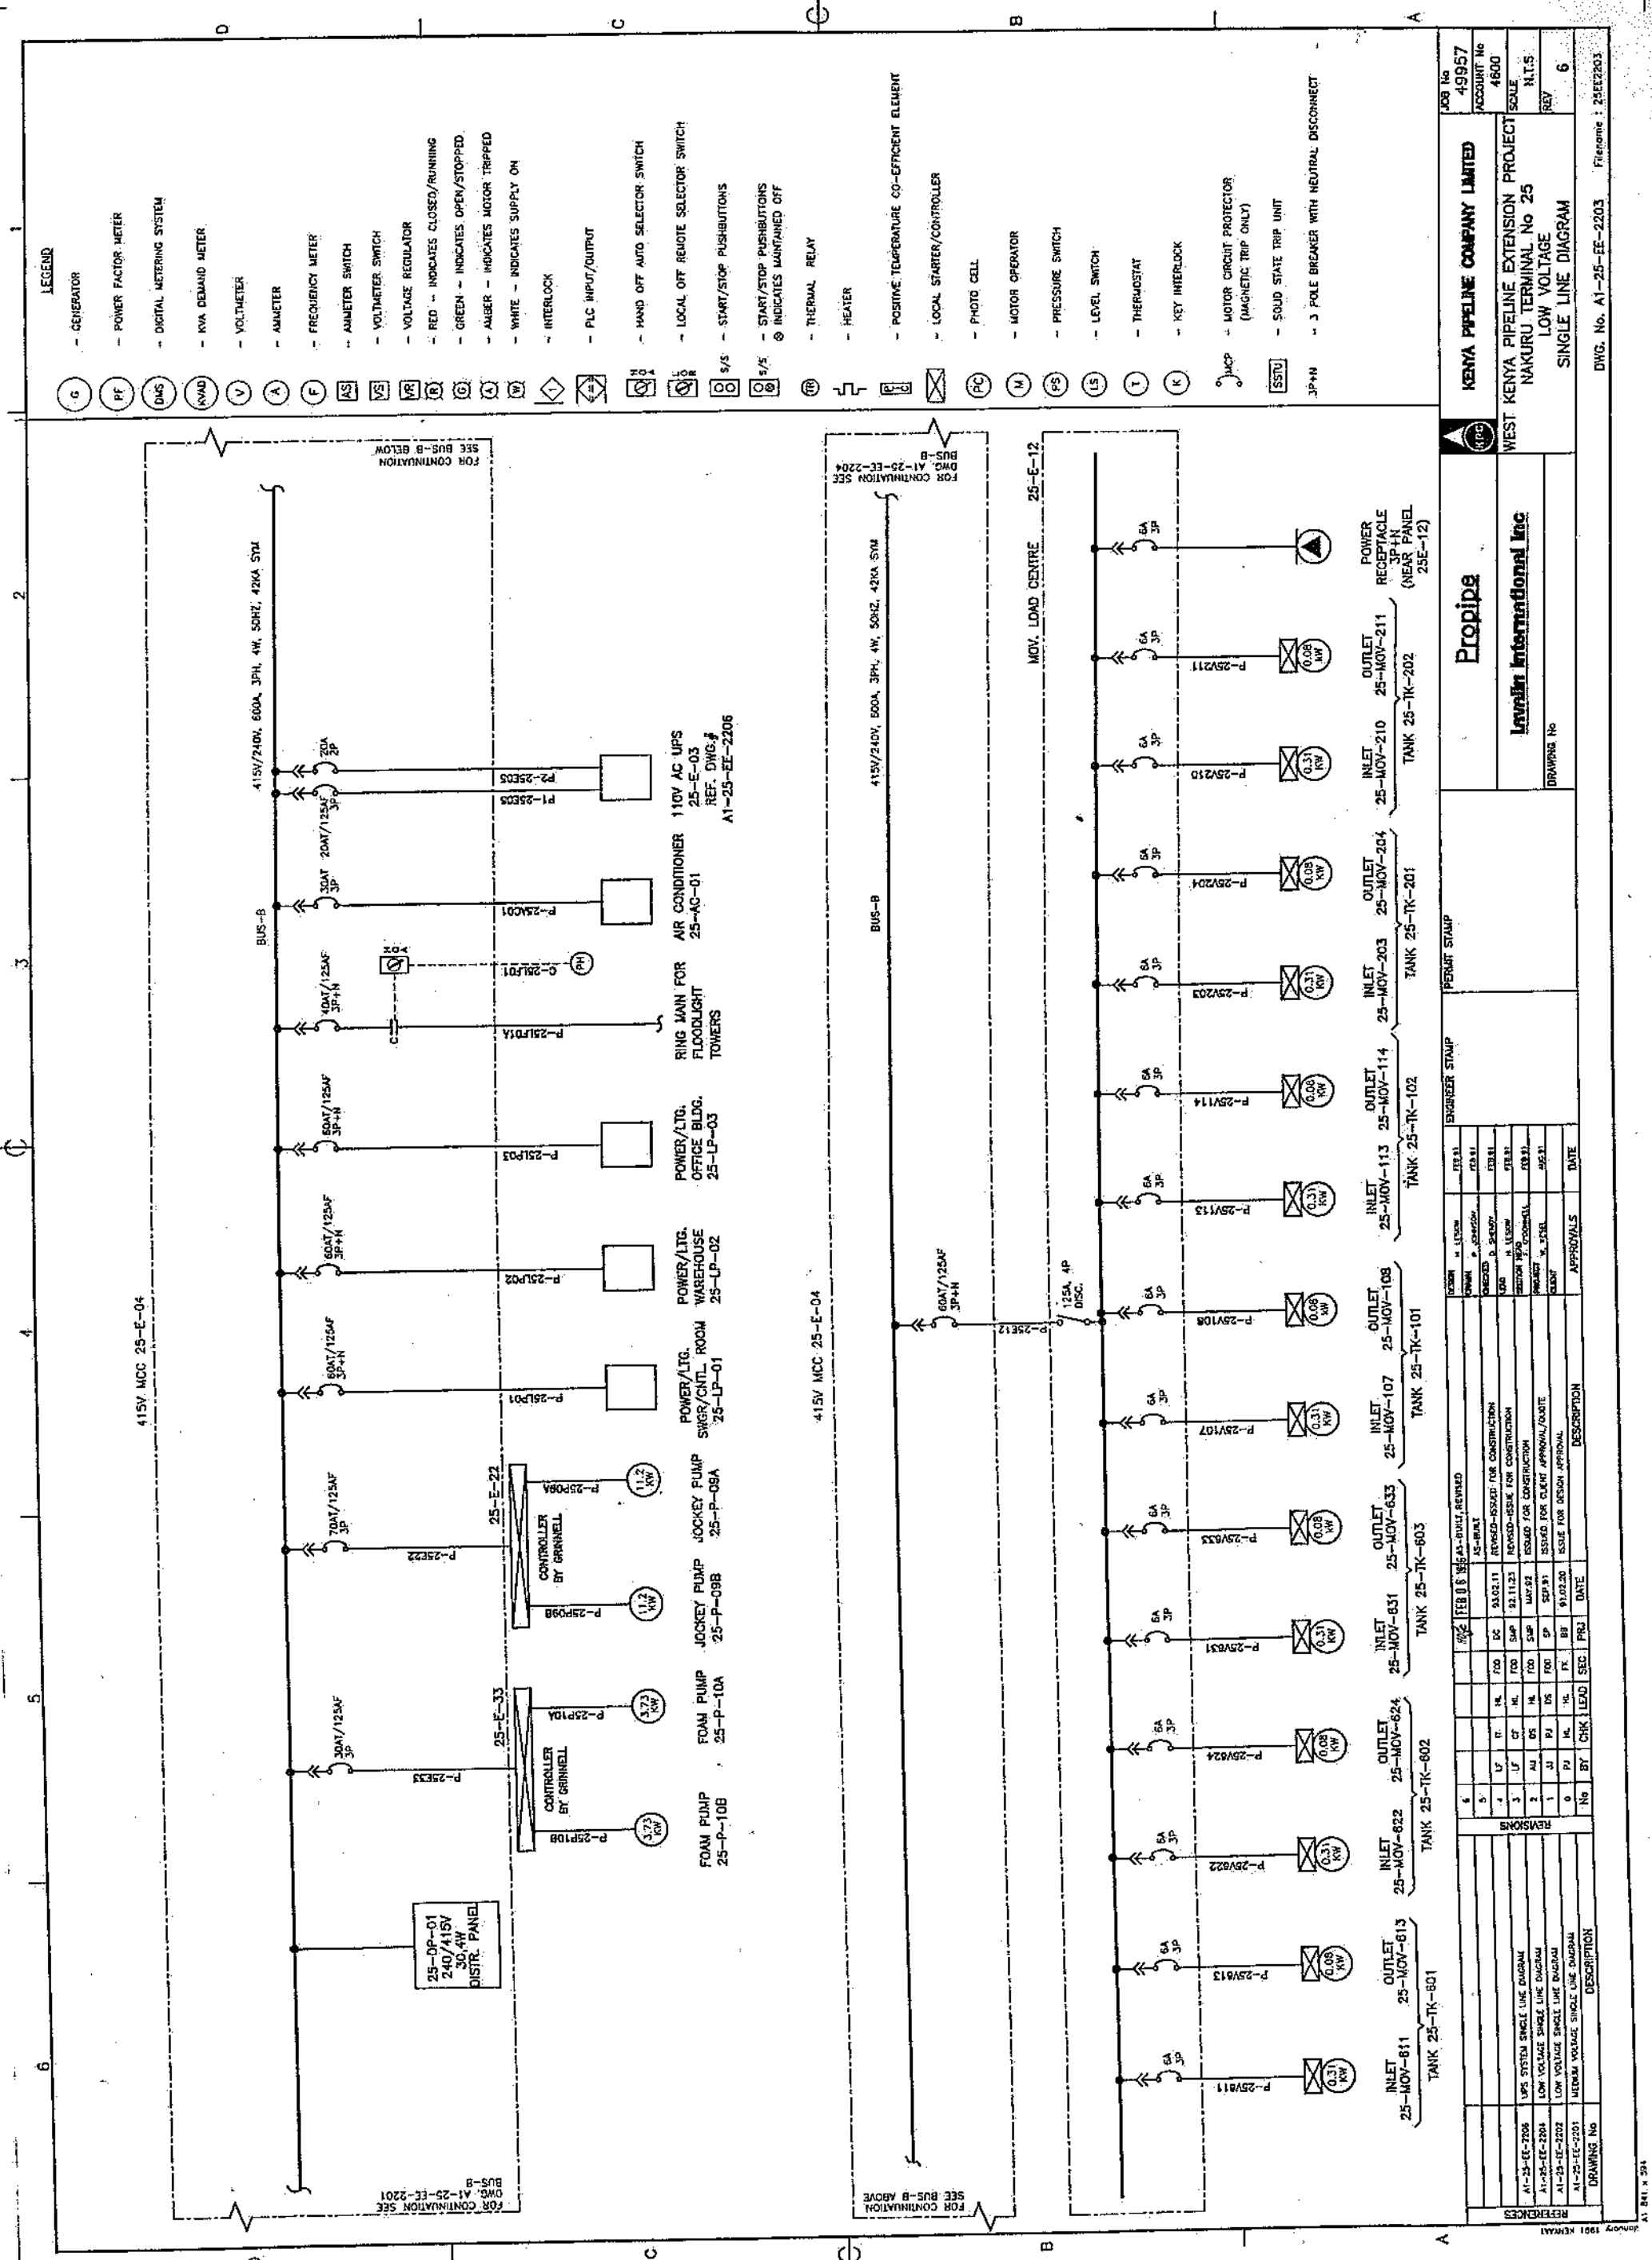

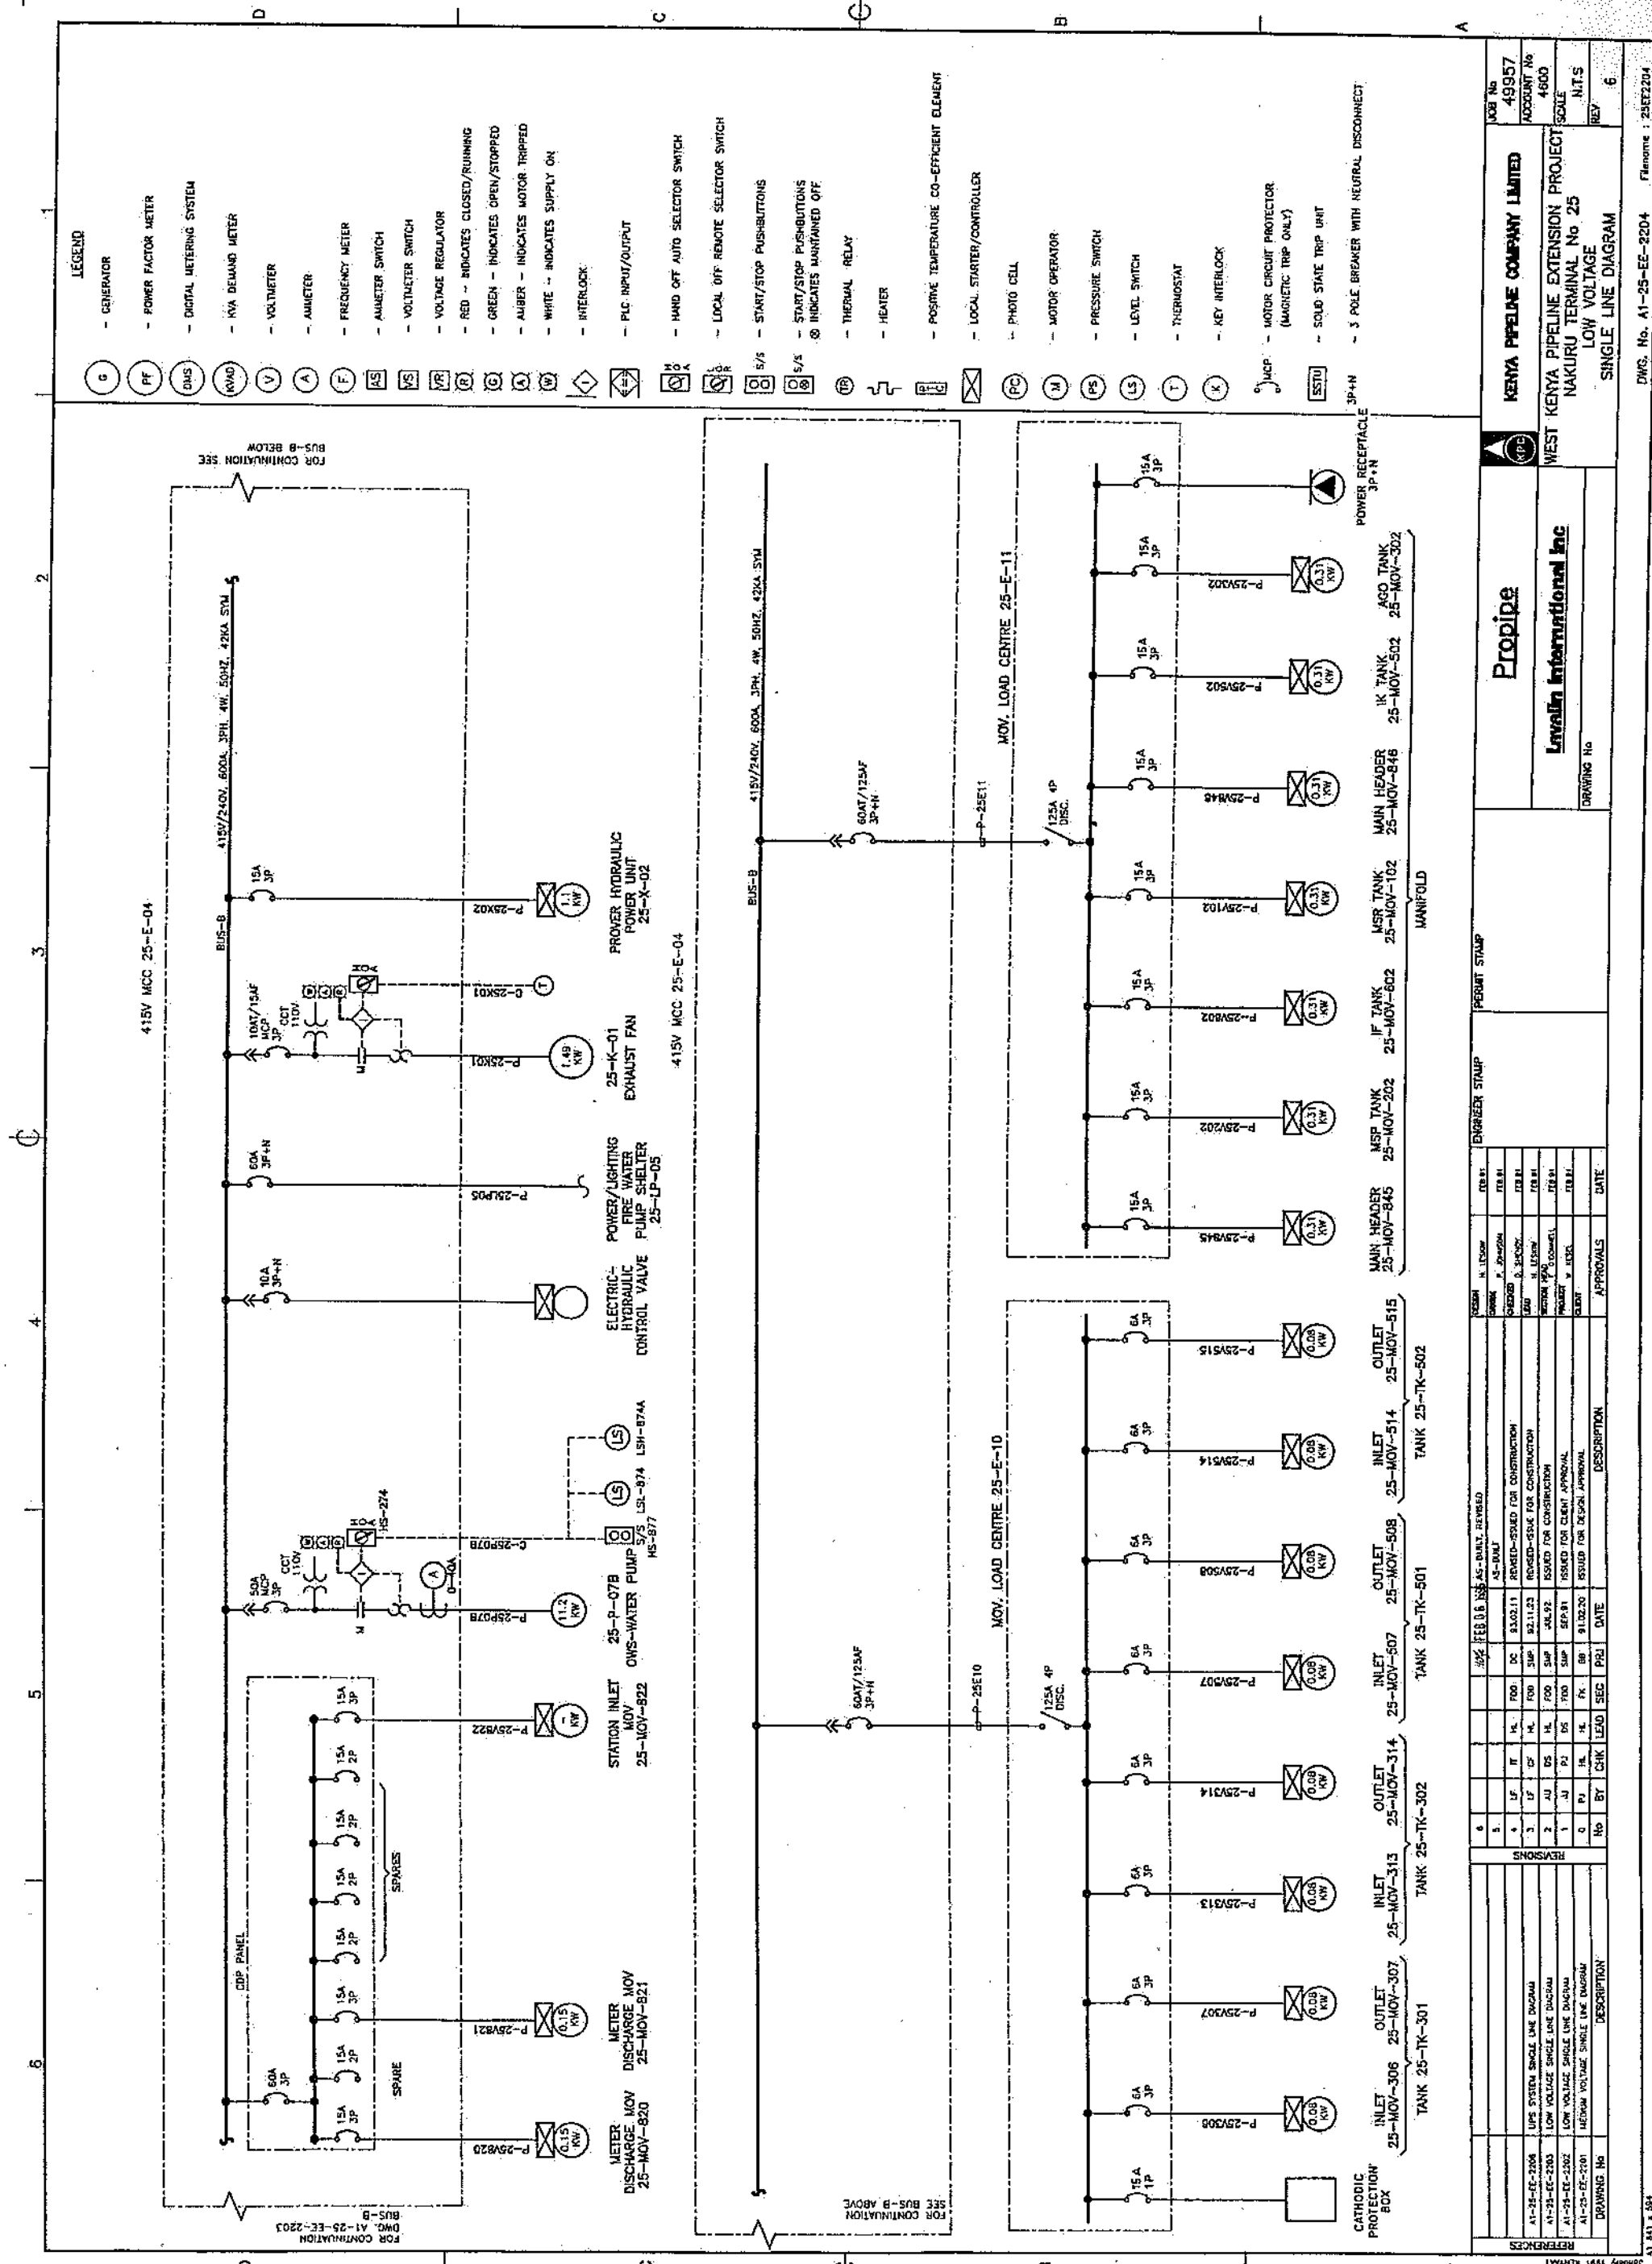

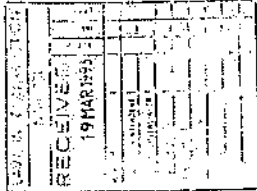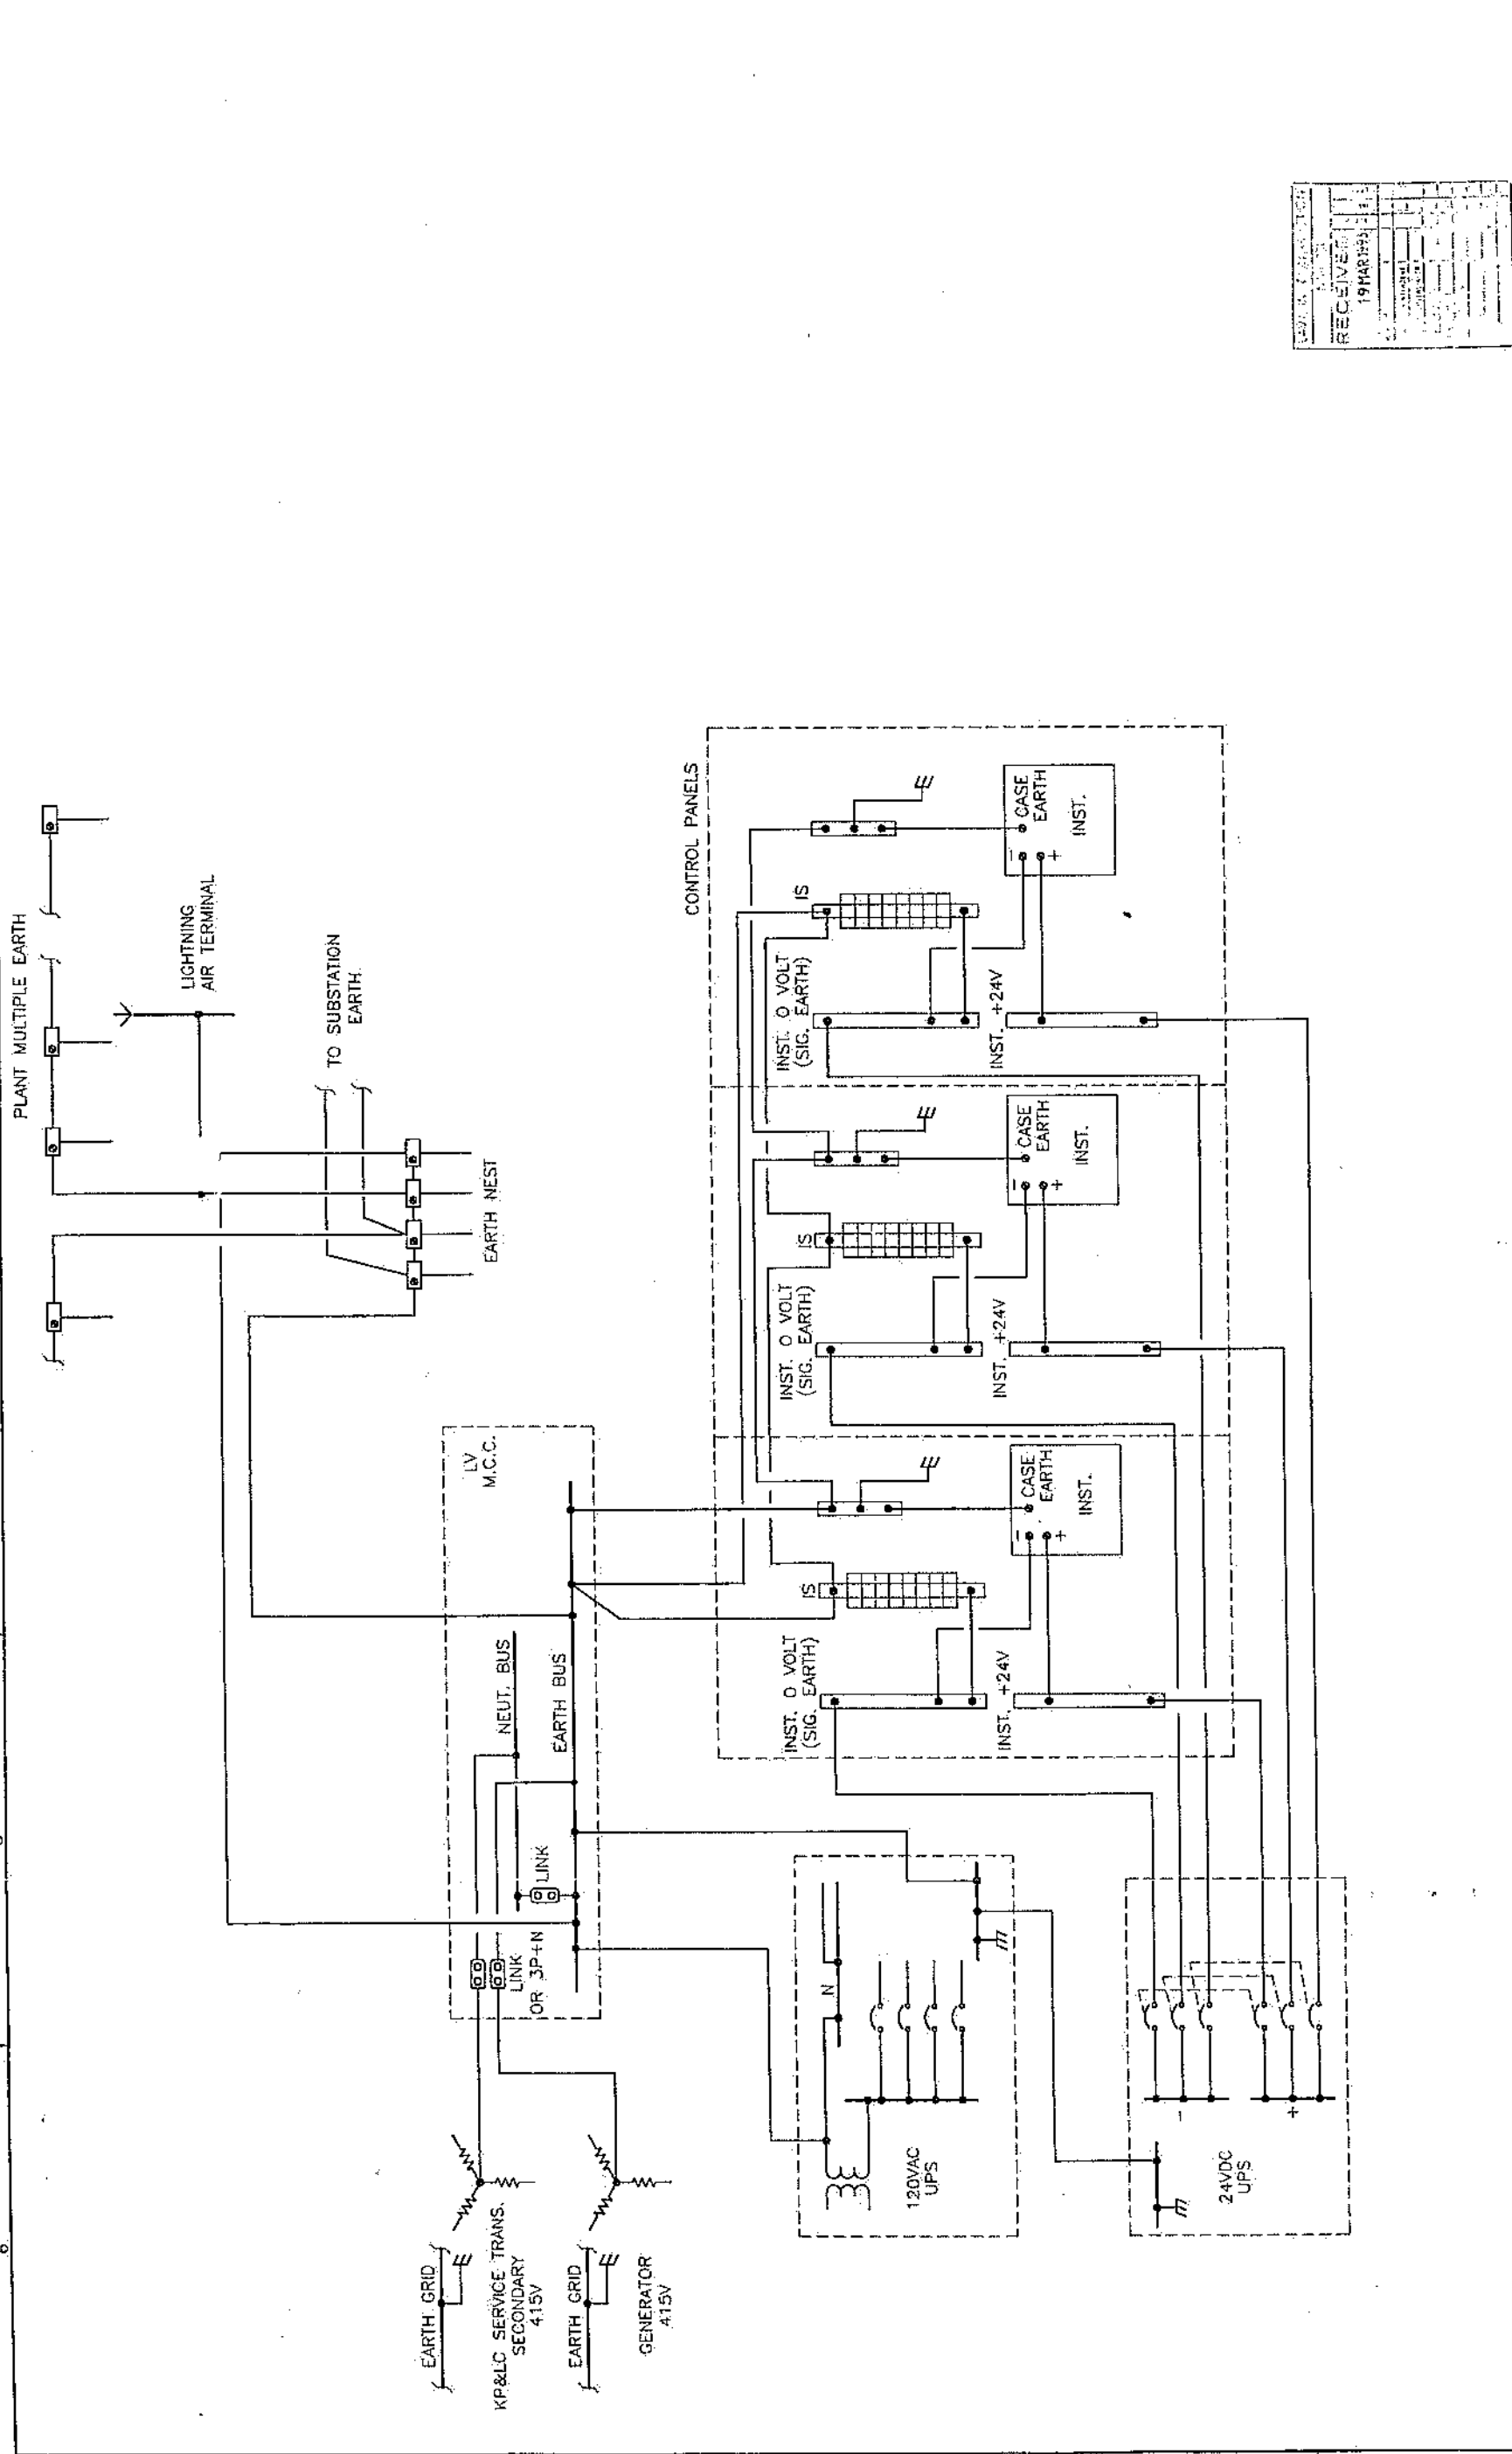

KENYA PIPELINE COMPANY LIMITED WEST KENYA PIPELINE EXTENSION PROJECT NAKURU TERMINAL No. 25 PLANT EARTHING SYSTEM SCHEMATIC		JOB No. 49957 ACCOUNT No. 4600 SCALE: INTS REV: 1					
Propipe Lavadin International Inc		DRAWING No.					
PERMIT STAMP							
ENGINEER STAMP							
REVISIONS							
No.	BY	CHK	LEAD	SEC	PRJ	DATE	DESCRIPTION
1	AS	AS	AS	AS	AS	12/11/92	ISSUED FOR CONSTRUCTION
2	AS	AS	AS	AS	AS	12/11/92	ISSUE FOR APPROVAL
3	AS	AS	AS	AS	AS	12/11/92	
4	AS	AS	AS	AS	AS	12/11/92	
5	AS	AS	AS	AS	AS	12/11/92	
6	AS	AS	AS	AS	AS	12/11/92	
APPROVALS							
DATE							
DESCRIPTION							
DRAWING No.							


DWG. No. A1-25-EE-2207 File name: 25EE2207



PLANT NORTH

S. 000.000
000.000

LEGEND

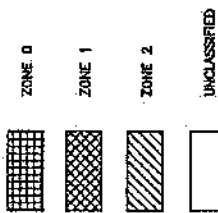

NOTES:

1. AREA CLASSIFICATIONS ARE TO IP MODEL CODE OF SAFE PRACTICE, PART 15
 2. IEC EQUIPMENT CLASSIFICATIONS FOR USE IN THE RESPECTIVE ZONES IS LISTED BELOW. ELECTRICAL MATERIAL AND METHOD OF INSTALLATION SHALL BE IN ACCORDANCE WITH THE INSTITUTE OF PETROLEUM (IP) MODEL CODE OF SAFE PRACTICE, PART 1 FOR THE RESPECTIVE ZONE.
 3. CS/VLL CERTIFIED EQUIPMENT CLASSIFICATIONS FOR USE IN THE RESPECTIVE ZONES IS SHOWN IN BRACKETS.
- ZONE 0
EQUIPMENT TO CLASSIFICATION Ex 1 a (INTRINSICALLY SAFE)
- ZONE 1
EQUIPMENT TO CLASSIFICATION Ex d MEX (CLASS 1, DIV 1, GROUP D T3)
- ZONE 2
EQUIPMENT TO CLASSIFICATION Ex e/Ex n MEX (CLASS 1, DIV 2, GROUP D T3)

PIPELINE TO NAKURU
PUMP STATION No. 24

HOLDING TANK
SEPTIC TANK

MAINT. TRENCH
APU

TRUCK LOADING
SHELTER ROOF
OUTLINE

CONCRETE
PAVEMENT
AREA

EMERGENCY
EXIT GATE
S. 80.000
LIGHT
TOWER

LABORATORY
OFFICE, CONTROL AND SHGR.
BUILDING SEE DWG'S.

STAFF/VISITORS
PARKING

GUARD HOUSE

ROAD

ROAD

25-TK-1902

25-TK-1903

25-TK-1904

25-TK-2154


25-TK-2155

25-TK-2156




PLANT NORTH

A MATCHLINE S. 163.000 FOR CONTINUATION SEE DWG. No. A1-25-EE-3101

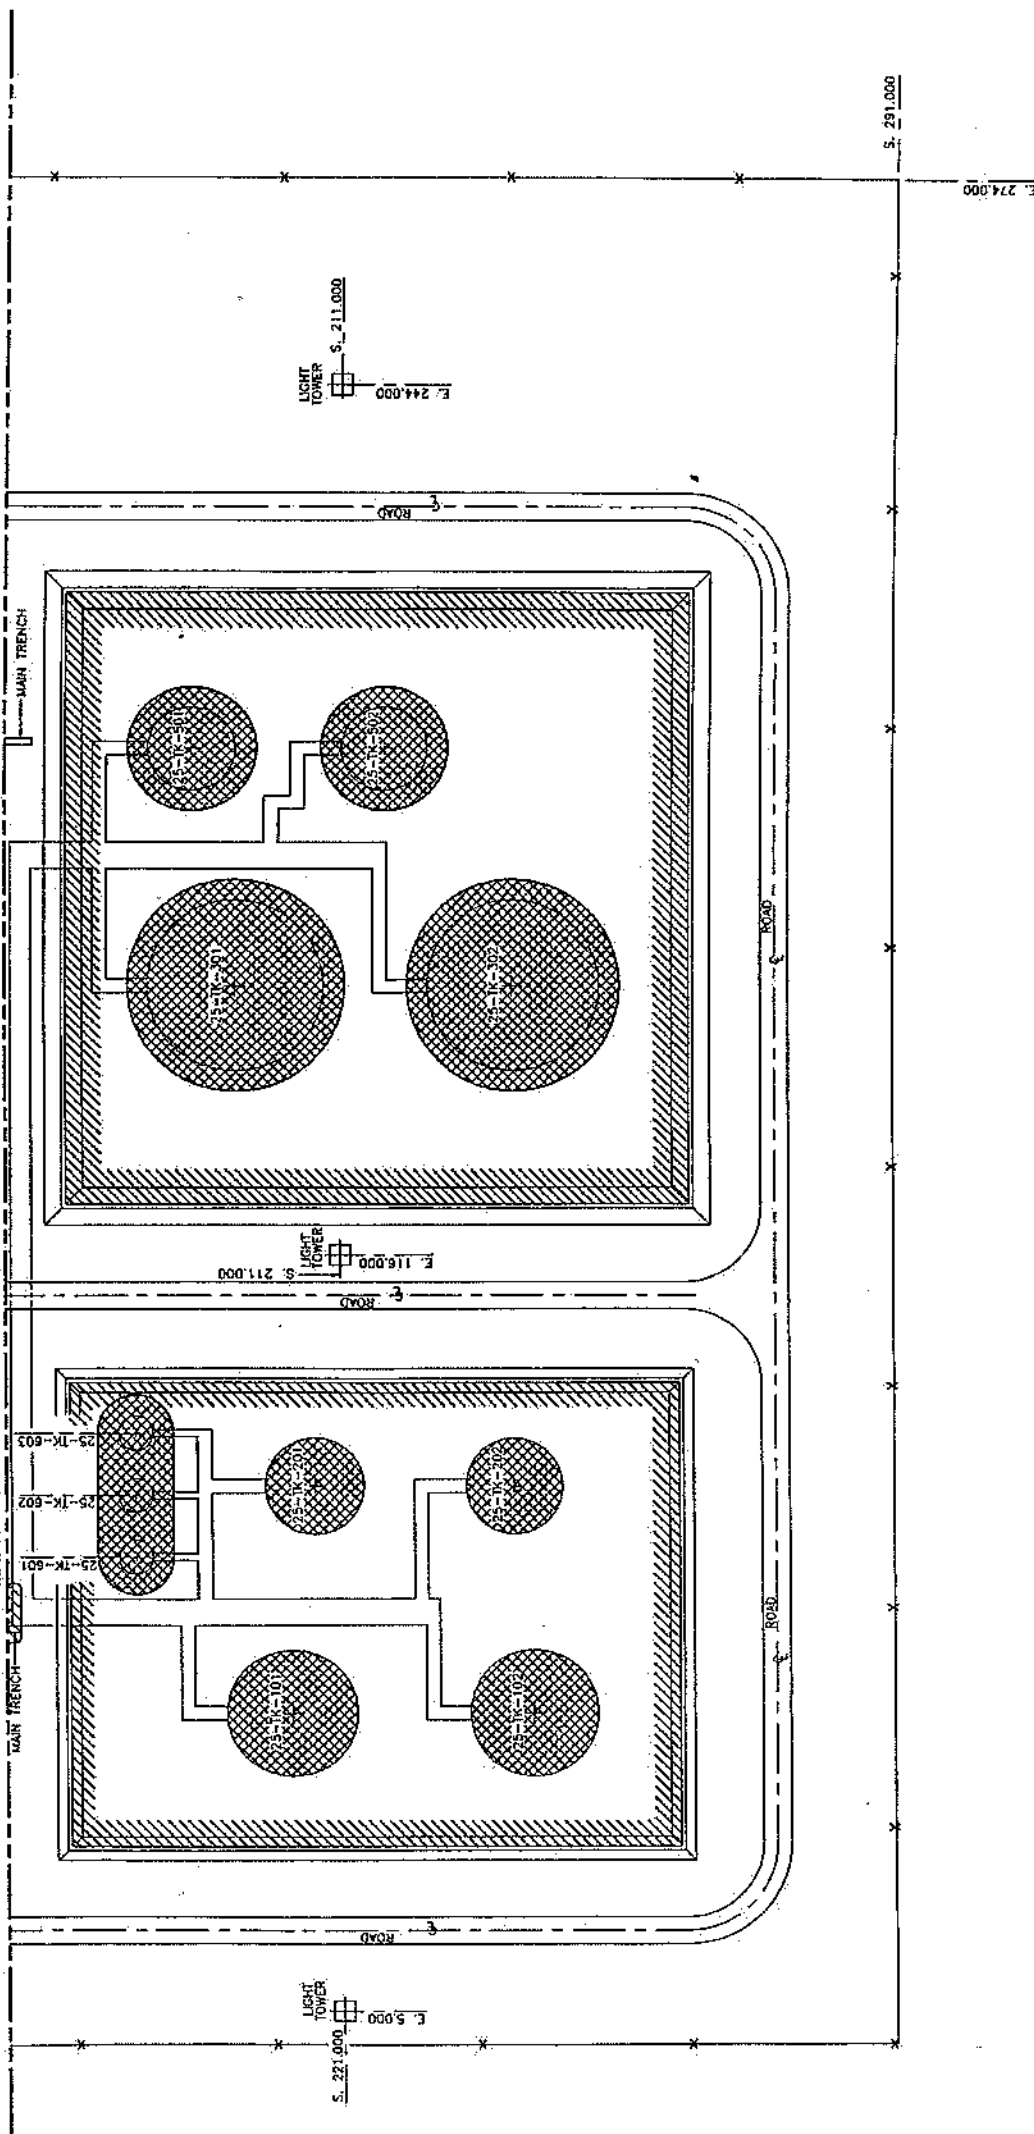

LEGEND

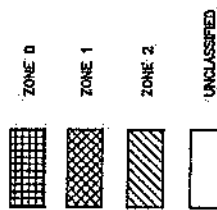


- NOTES:
1. AREA CLASSIFICATIONS ARE TO IP MODEL CODE OF SAFE PRACTICE, PART 15.
 2. IEC EQUIPMENT CLASSIFICATIONS FOR USE IN THE RESPECTIVE ZONES IS LISTED BELOW.
 3. CSA/UL CERTIFIED EQUIPMENT CLASSIFICATIONS FOR USE IN THE RESPECTIVE ZONES IS SHOWN IN BRACKETS.

ZONE 0
EQUIPMENT TO CLASSIFICATION Ex I a (INTRINSICALLY SAFE)


ZONE 1
EQUIPMENT TO CLASSIFICATION Ex d IAT3
(CLASS 1, DIV 1, GROUP D T3)

ZONE 2
EQUIPMENT TO CLASSIFICATION Exe/Exn IAT3
(CLASS 1, DIV 2, GROUP D T3)

KENYA PIPELINE COMPANY LIMITED		Propipe		ENGINEER STAMP		PERMIT STAMP	
JOB No	49957	DRAWING No		DATE		DATE	
ACCOUNT No	4800	SCALE		APPROVALS		APPROVALS	
WEST KENYA PIPELINE EXTENSION PROJECT		NAKURU TERMINAL No. 25		REVISIONS		REVISIONS	
AREA CLASSIFICATION PLAN		SOUTH		DESCRIPTION		DESCRIPTION	
DRAWING No		REV		No		No	
5		1:500		BY		BY	
DWG. No. A1-25-EE-3102		Filename: 25EE3102		DATE		DATE	

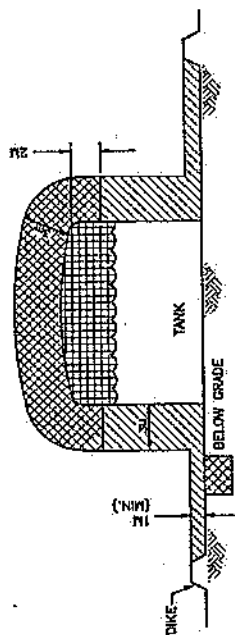


IP (PART 15) SECT. 3.2.1
IP (PART 15) SECT. 6.5.1.3

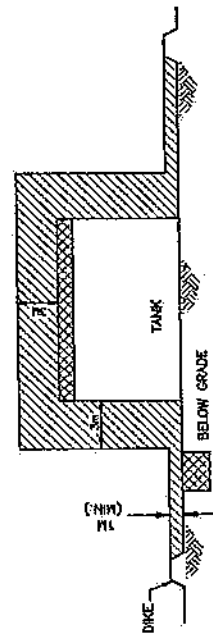


FLOATING ROOF TANK

IP (PART 15) SECT. 3.2.2
IP (PART 15) SECT. 8.5.1.3

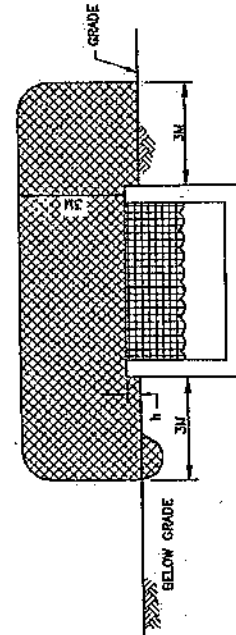


OILY WATER STORAGE TANK SECTION

IP (PART 15) SECT. 5.12
IP (PART 15) SECT. 6.5.1.3

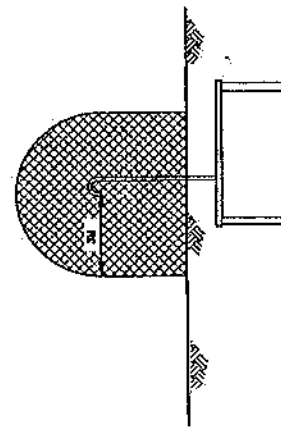


SUMP TANK VENTING

IP (PART 15) SECT. 5.12.8
IP (PART 15) SECT. 5.14

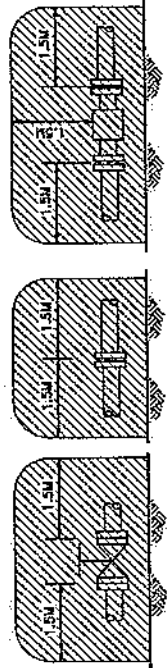


TYPICAL VALVE/FLANGE/METER LOCATION

IP (PART 15) SECT. 5.10.3
IP (PART 15) SECT. 5.10.5

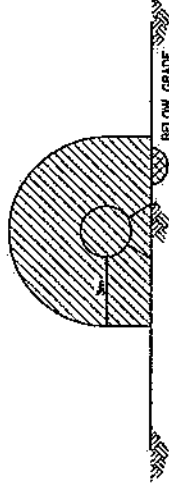


OUTDOOR PUMP.

IP (PART 15) SECT. 5.6.2
IP (PART 15) SECT. 6.5.1.3

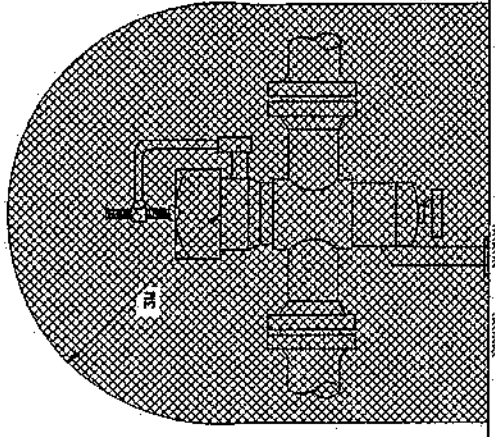


TYPICAL STRAINER/VESSEL

100 (PART. 15) SECT. 5.6.1

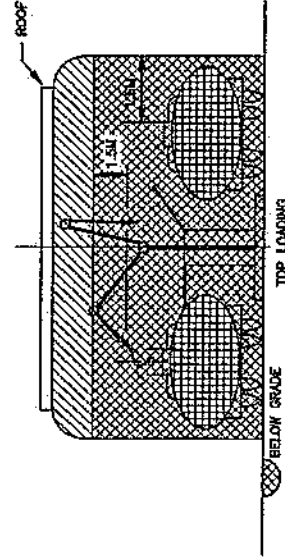ROAD LOADING

IP (PART 15) SECT. 1.3
IP (PART 15) SECT. 0.5.1.3

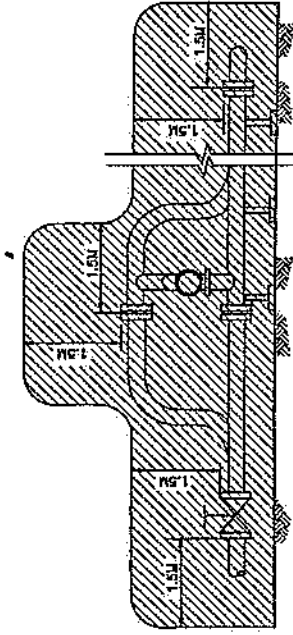

PROVER

IP (PART 15) SECT. 5.10.3
IP (PART 15) SECT. 5.10.5

[illegible]

